



State of Rhode Island
Coastal Resources Management Council
Oliver H. Stedman Government Center
4808 Tower Hill Road, Suite 3
Wakefield, RI 02879-1900

(401) 783-3370
Fax (401) 783-2069

PUBLIC NOTICE

File Number: 2026-07-058 Date: August 12, 2026

This office has under consideration the application of the:

City of Providence
c/o Joseph I. Mulligan III, Planning & Development
444 Westminster Street
Providence, RI 02903

for a State of Rhode Island Assent for the project described below:

The City of Providence Riverwalk Resilience Project (the Project) aims to re-build the Providence Riverwalk and Waterpark Basin. The Project will include several components: 1) replacing the existing Riverwalk entrance stairway at Finance Way with a switchback ramp walkway and stairway (Finance Way and Francis Street Gateway); 2) replacing the existing Waterplace Pedestrian Bridge; (3) replacing two existing kayak launches in-kind and installing a new kayak launch; (4) improving the existing Riverwalks along the northern and southern sides of the Woonasquatucket River including masonry repairs, such as repainting of the Riverwalk seawalls; (5) installing living seawall panels along the northern river between Waterplace Pedestrian Bridge and Exchange Street Bridge; (6) maintenance dredging extending from Francis Street bridge through the Waterplace Basin and downstream Steeple Street; (7) installing flood barriers and security gates within the Memorial Boulevard Tunnel; (8) constructing an elevated, shared-use walkway between Memorial Boulevard and 50 Exchange Terrace; (9) roadway alterations and signal upgrades along Memorial Boulevard; (10) installing new site amenities, including benches, lighting, railings, and entrance portal elements; and (11) improvements to stormwater management systems which would include modifications to existing outfalls and 6 new outfalls.

Project Location:	12 Memorial Boulevard
City/Town:	Providence
Plat/Lot:	Plat 19; lots 102, 103, 109, 114, 118, 123, 127, 129, 131, 137, 138
Waterway:	Woonasquatucket River

Plans of the proposed work can be requested at Cstaff1@crmc.ri.gov.

In accordance with the Administrative Procedures Act (Chapter 42-35 of the Rhode Island General Laws) you may request a hearing on this matter.

You are advised that if you have good reason to enter protests against the proposed work it is your privilege to do so. It is expected that objectors will review the application and plans thoroughly, visit site of proposed work if necessary, to familiarize themselves with the conditions and cite what law or laws, if any, would in their opinion be violated by the work proposed.

If you desire to protest, you must attend the scheduled hearing and give sworn testimony. A notice of the time and place of such hearing will be furnished you as soon as possible after receipt of your request for hearing. If you desire to request a hearing, to receive consideration, it should be in writing (**with your correct mailing address, e-mail address and valid contact number**) and be received at this office on or before **September 12, 2026**.

Please email your comments/hearing requests to: cstaff1@crmc.ri.gov; or mail via USPS to: Coastal Resources Management Council; O. S. Government Center, 4808 Tower Hill Road, Rm 116; Wakefield, RI 02879.

/lat

Figure 1: Project Overview Map
Providence Riverwalk Resilience Project | Providence, RI


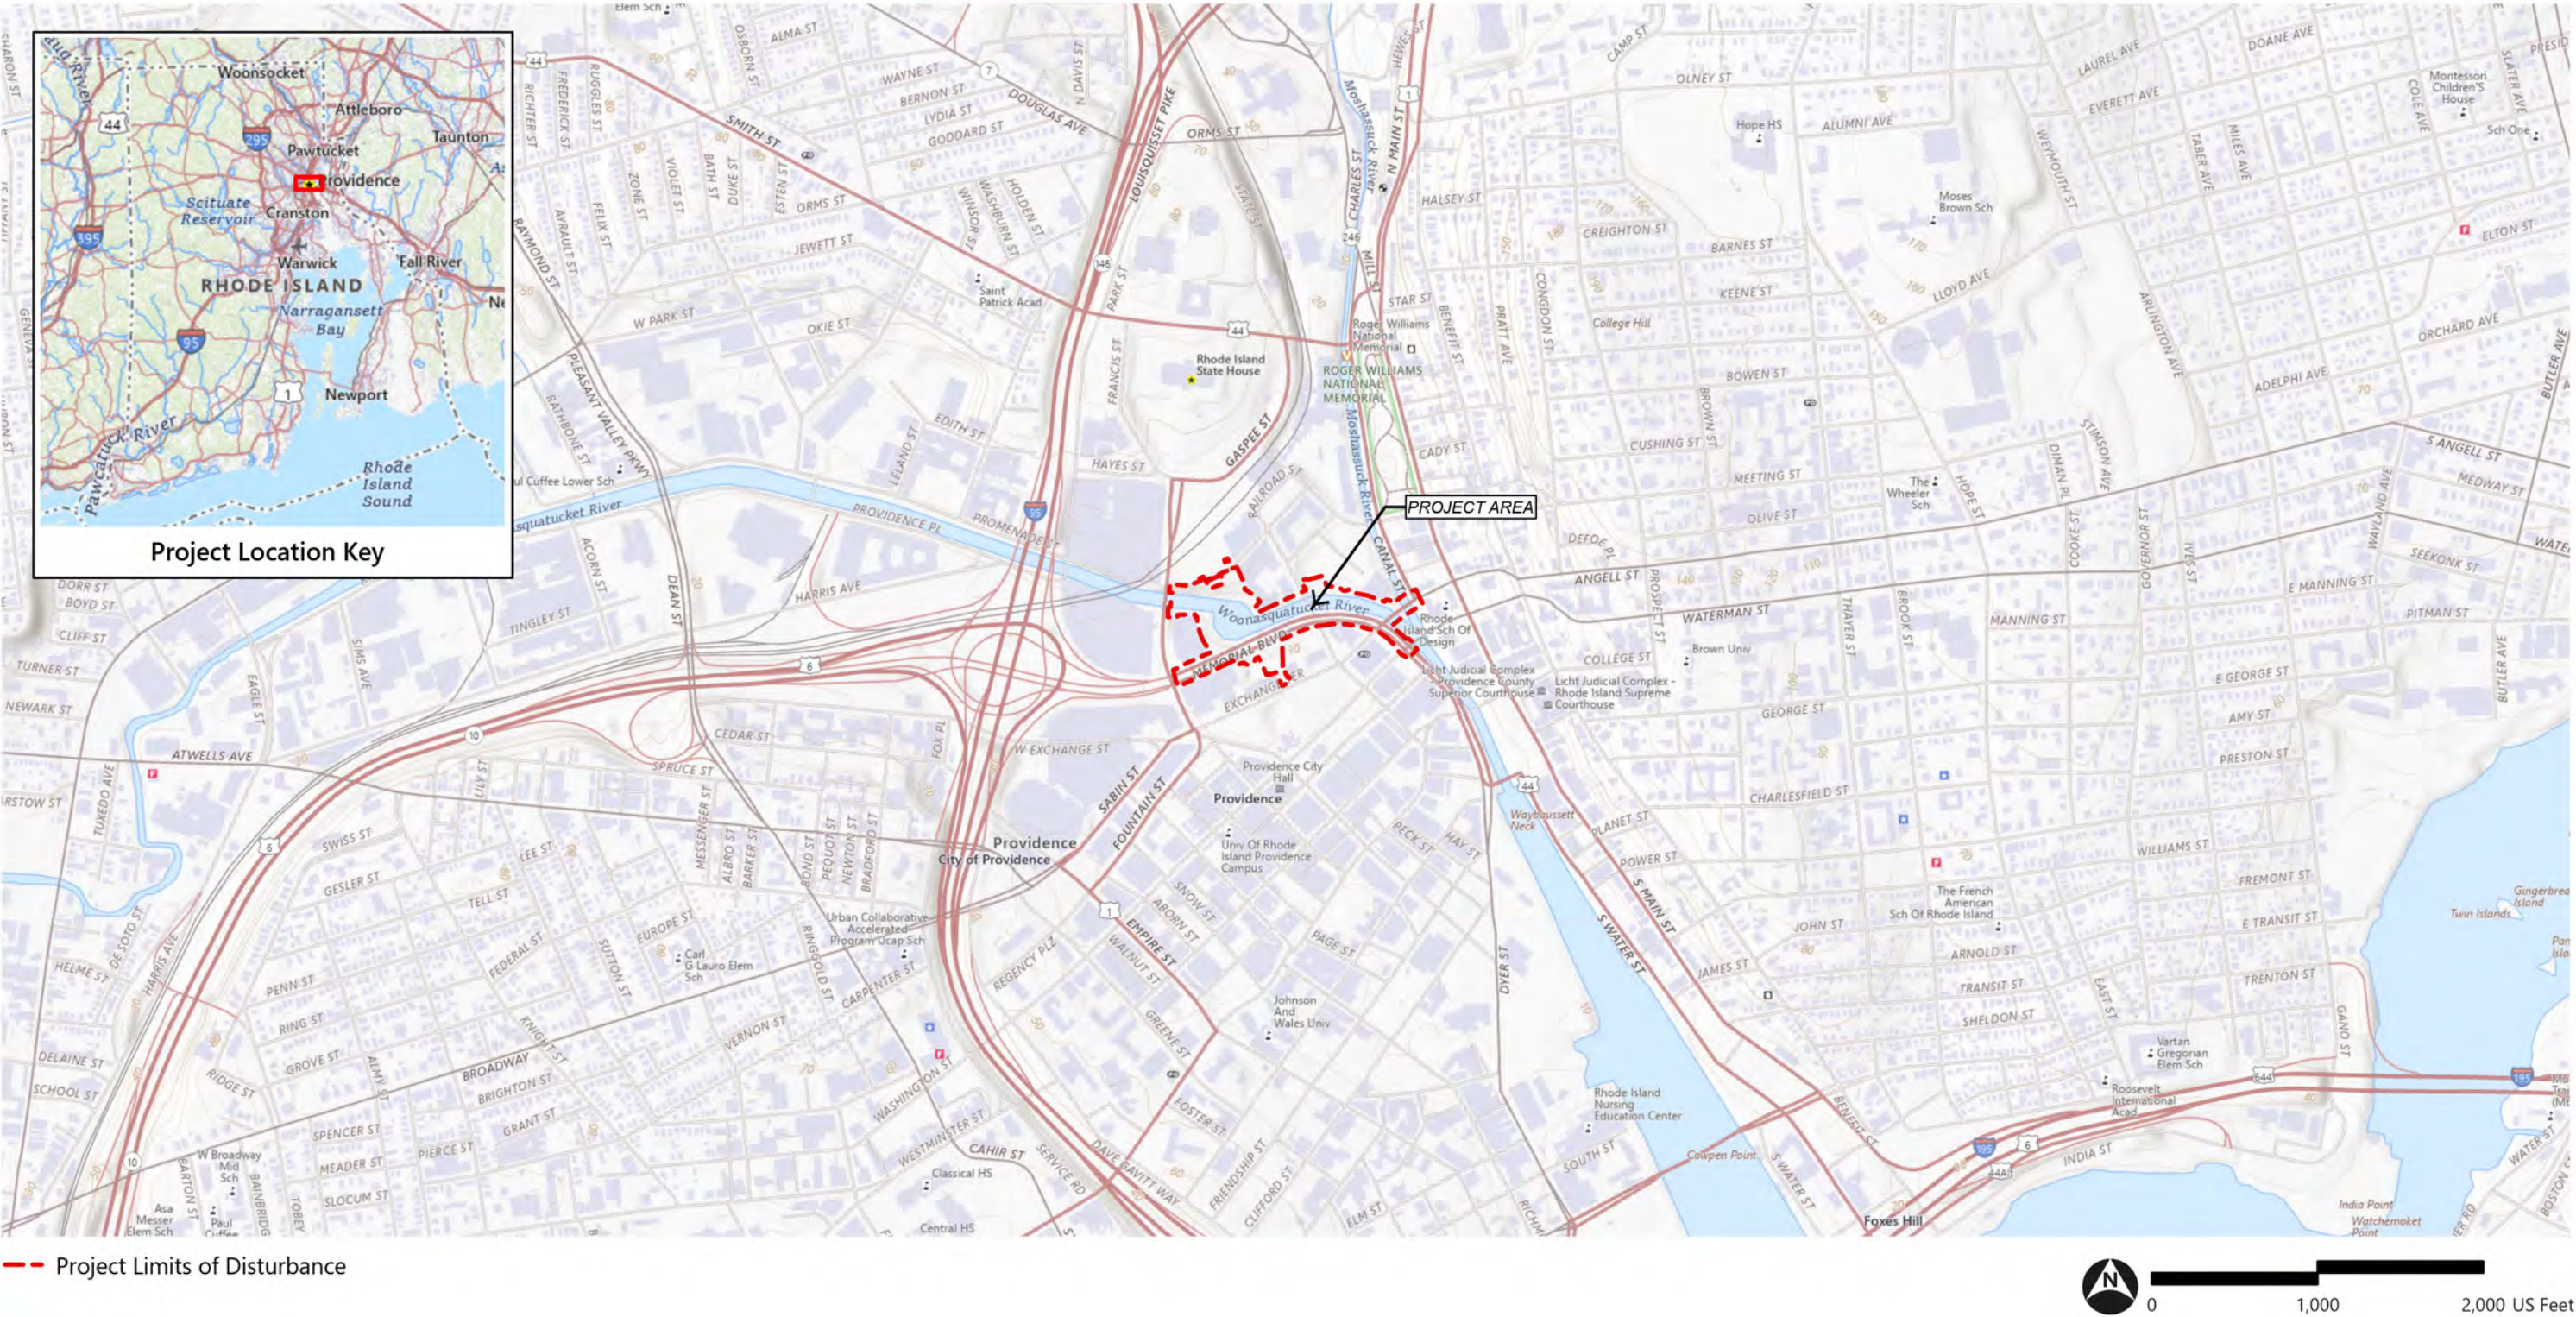


Figure 2: Proposed Project Work Area
Providence Riverwalk Resilience Project | Providence, RI

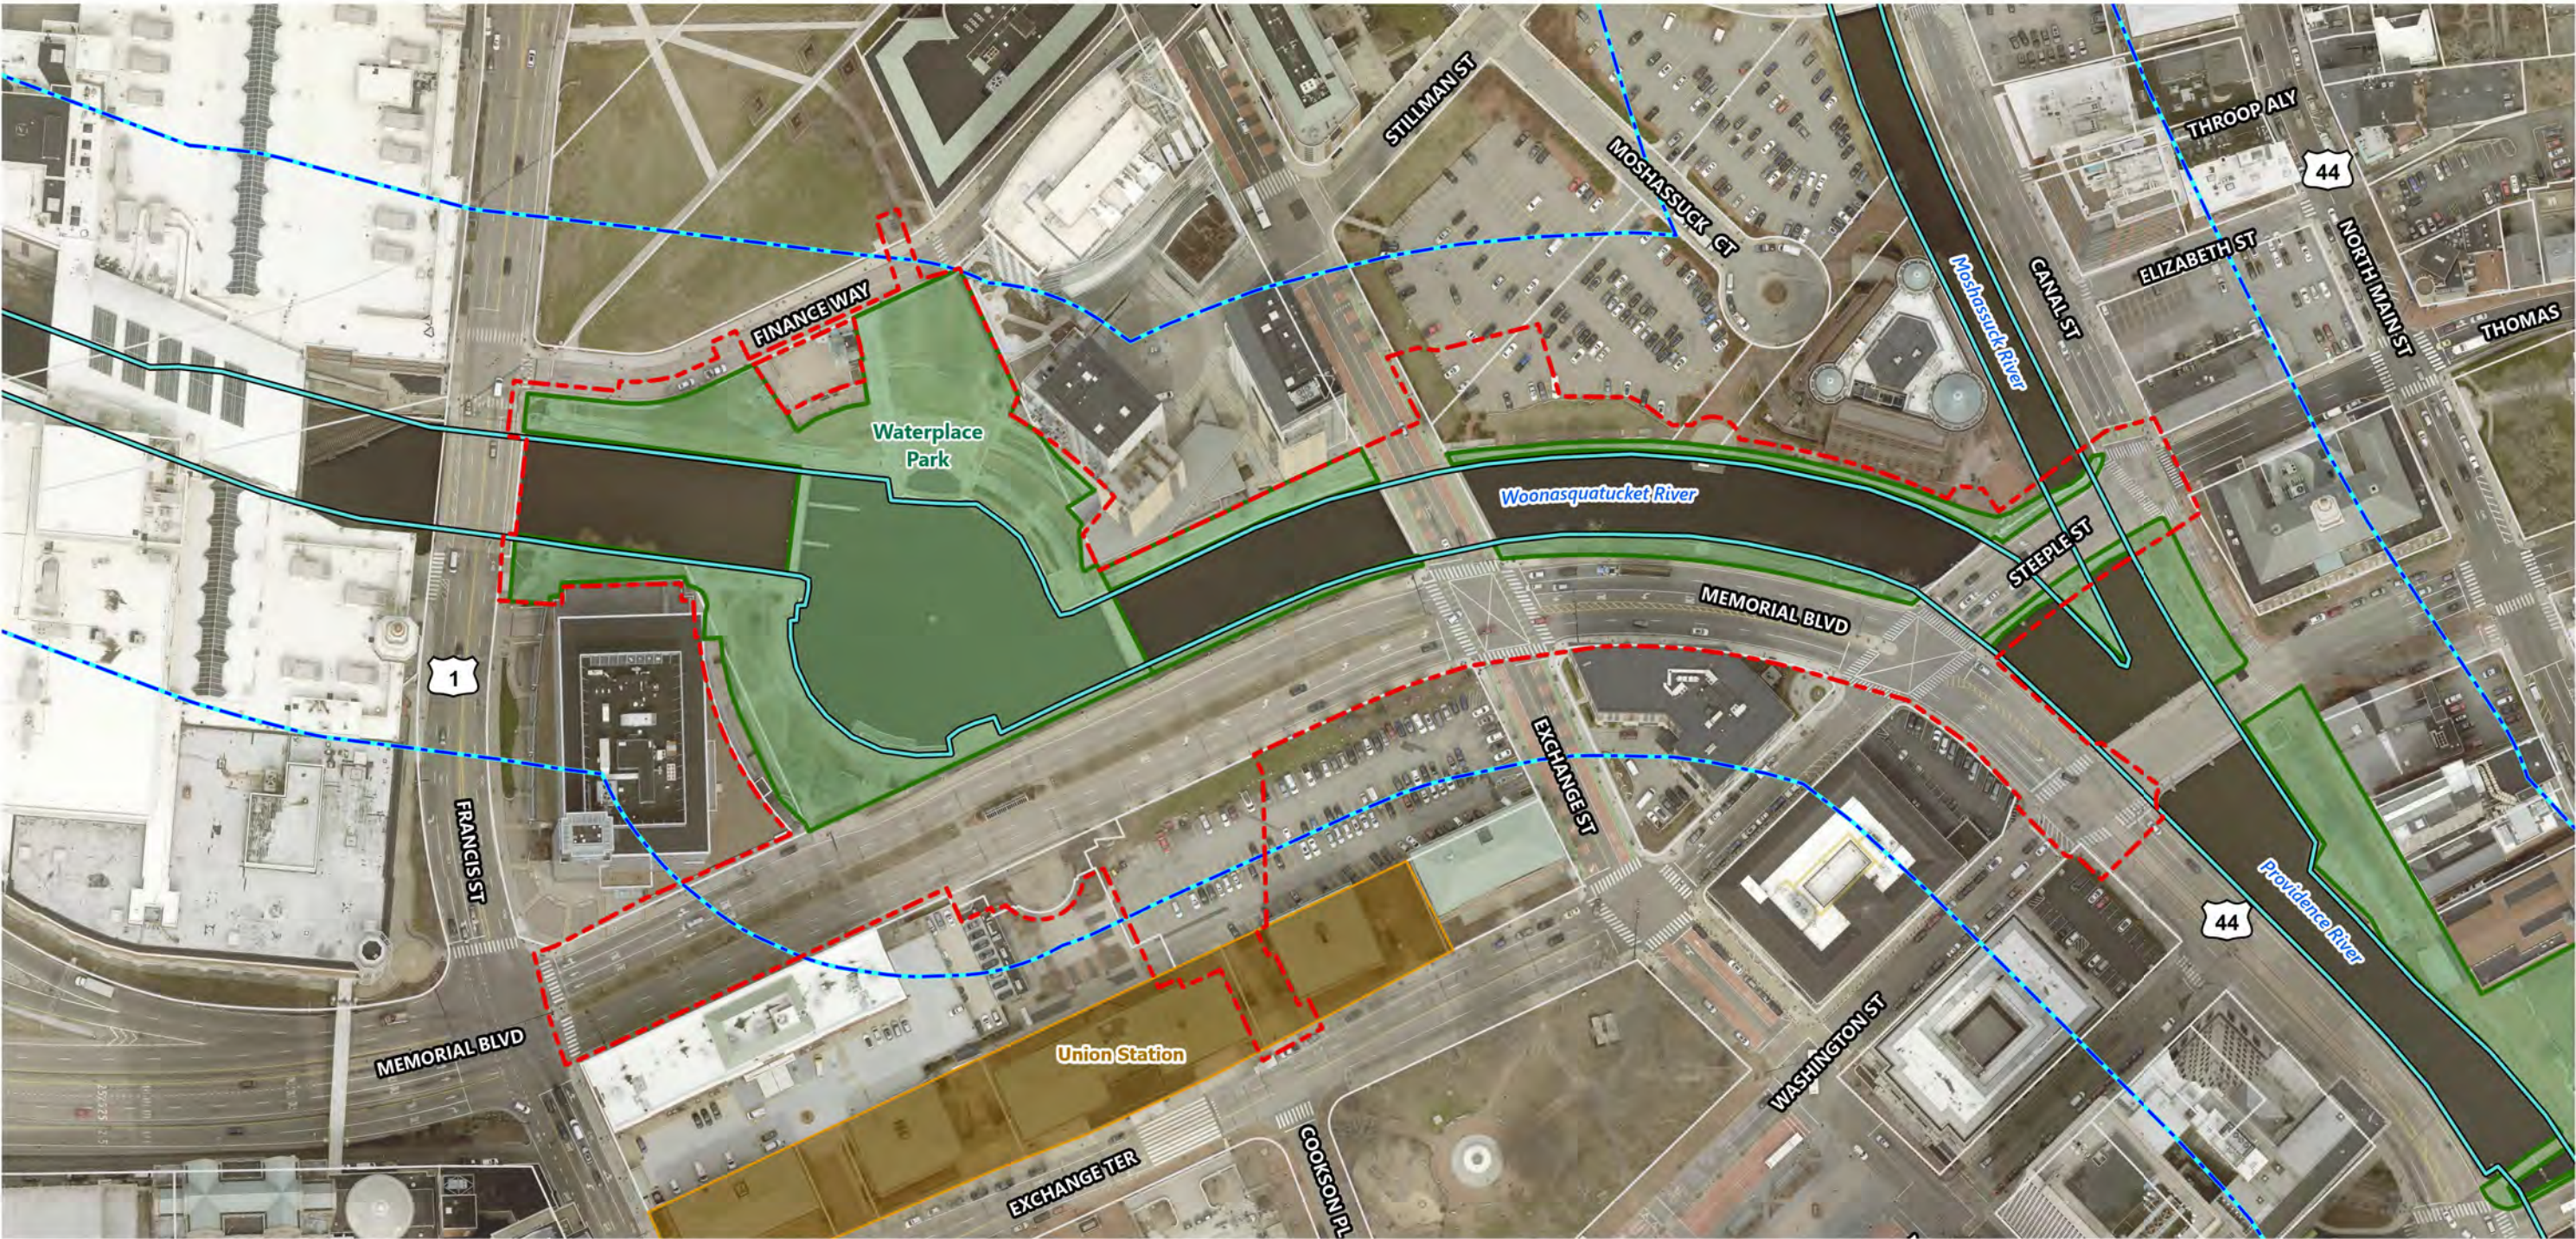

- Project Limits of Disturbance
- Approximate Manmade Shoreline
- Parcel Boundary
- Historic Properties
- 200-foot CRMC Contiguous Area
- Park and Recreation Property


 


Figure 3: CRMC Water Type Classification Mapping

Providence Riverwalk Resilience Project | Providence, RI

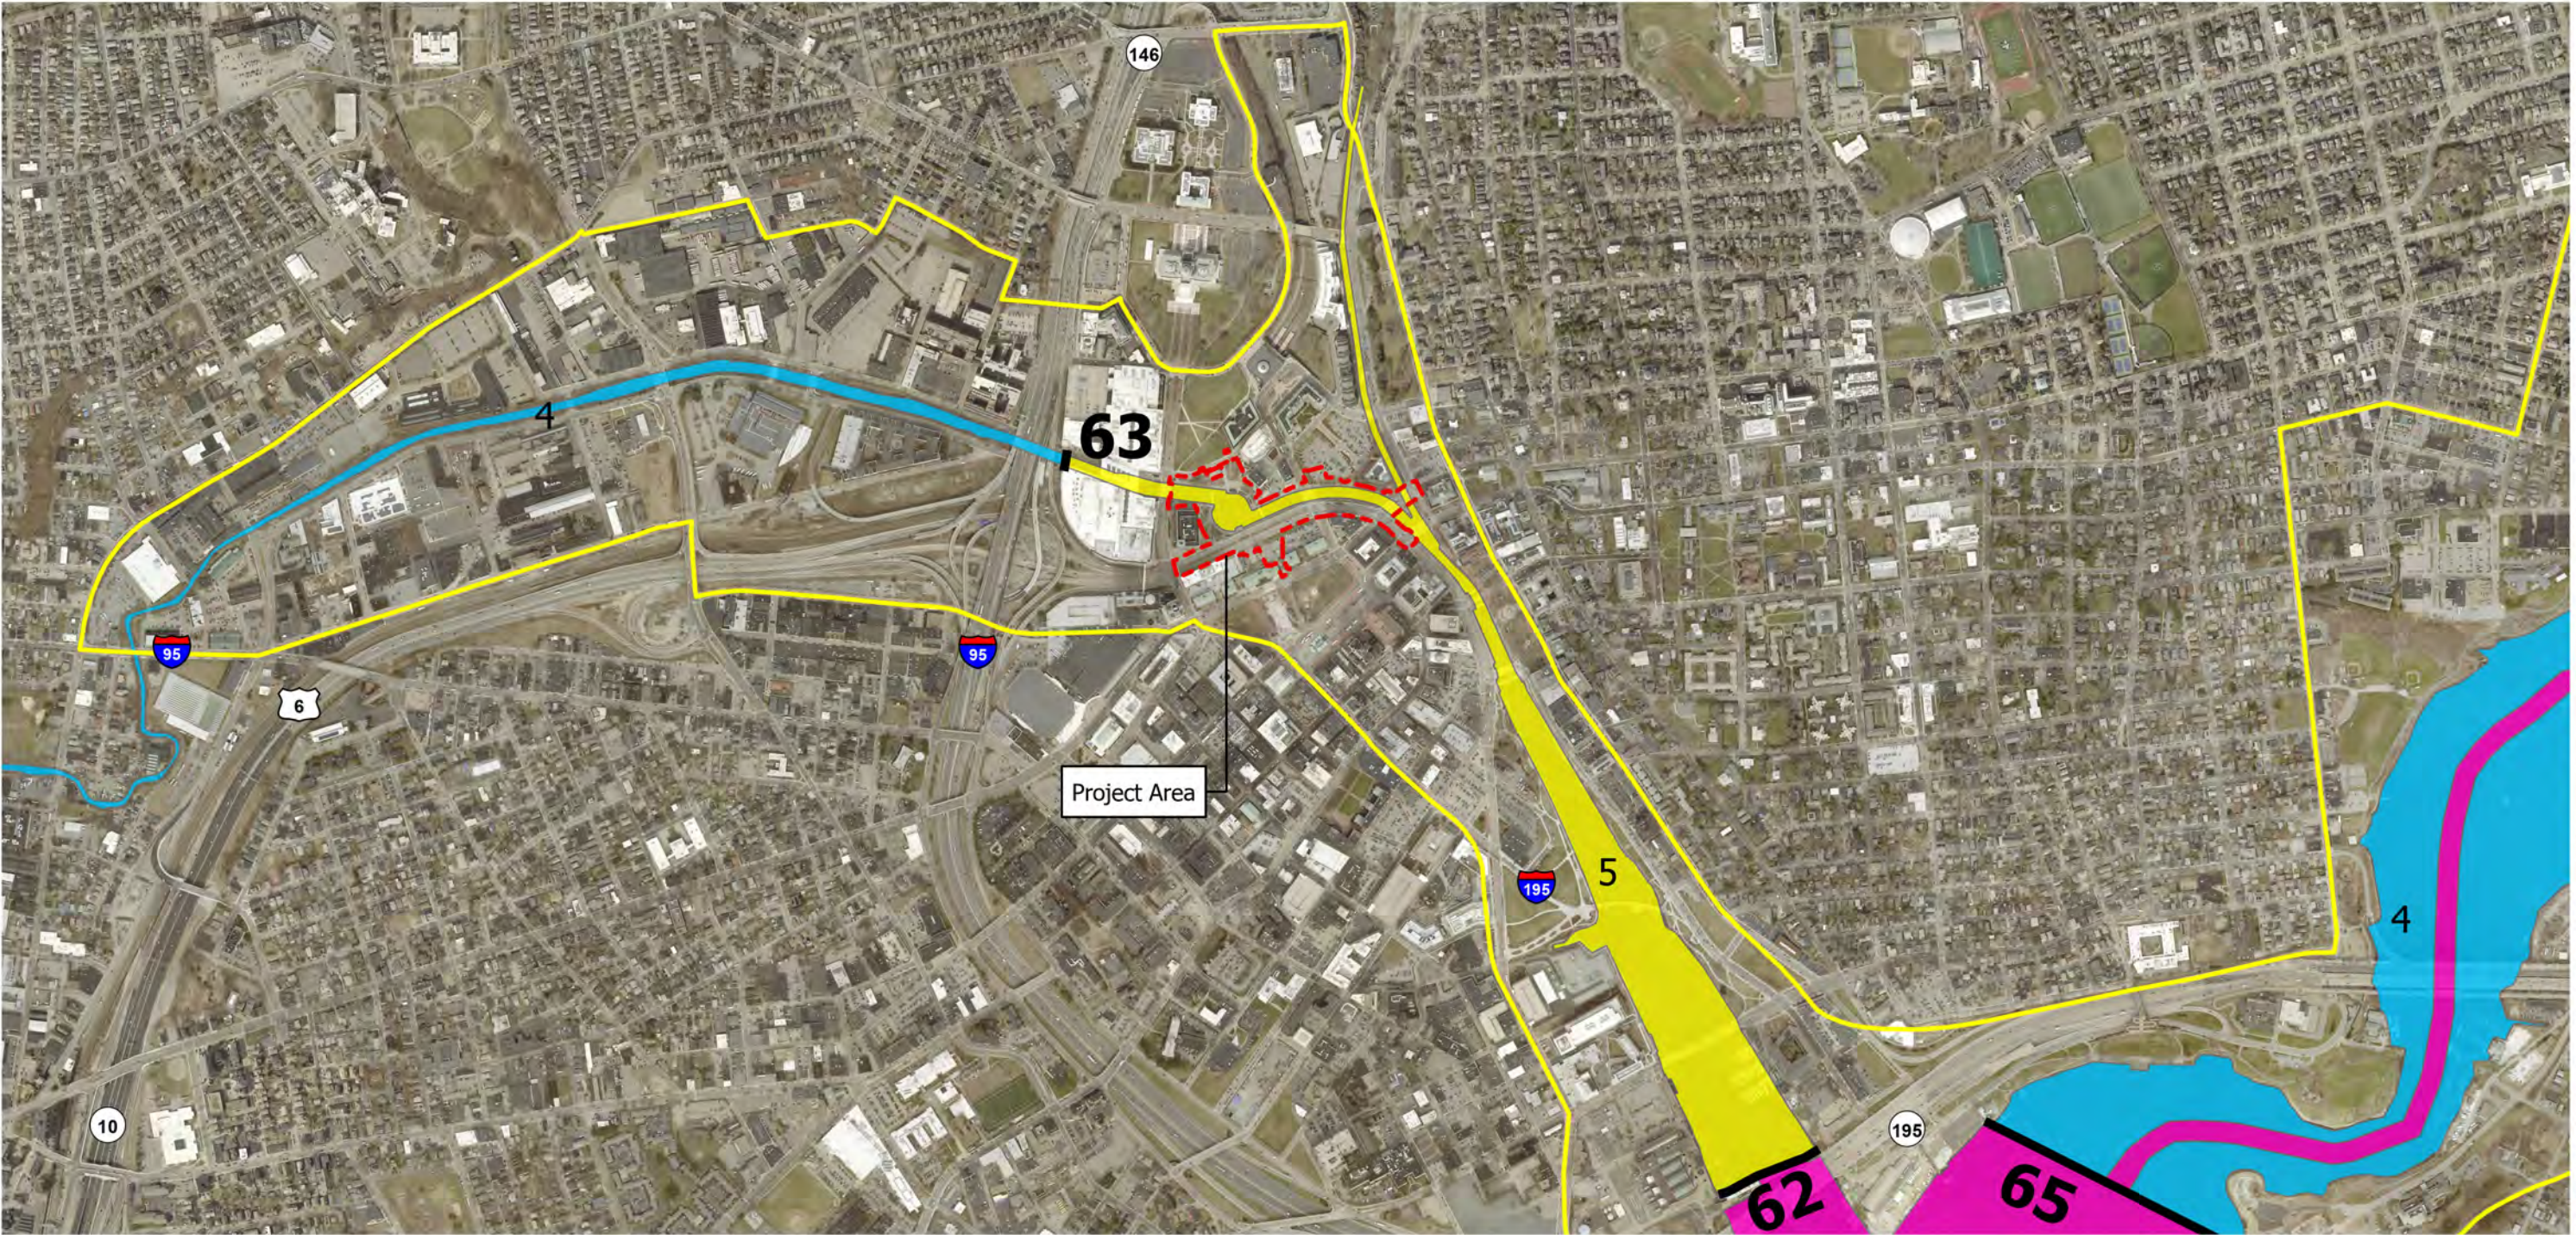

Project Limits of Disturbance

CRMC Water Type Classifications

4 Multi Purpose Waters

5 Recreational and Commercial Harbors

6 Industrial Waterfronts and Commercial Navigation Channels

Water Types Boundary


Metro Bay SAMP Boundary

0

1,000

2,000 US Feet

Source: VHB; RIGIS; NearMap; CRMC Water Type Classification Mapping for Providence, RI, Accessed January 2026.

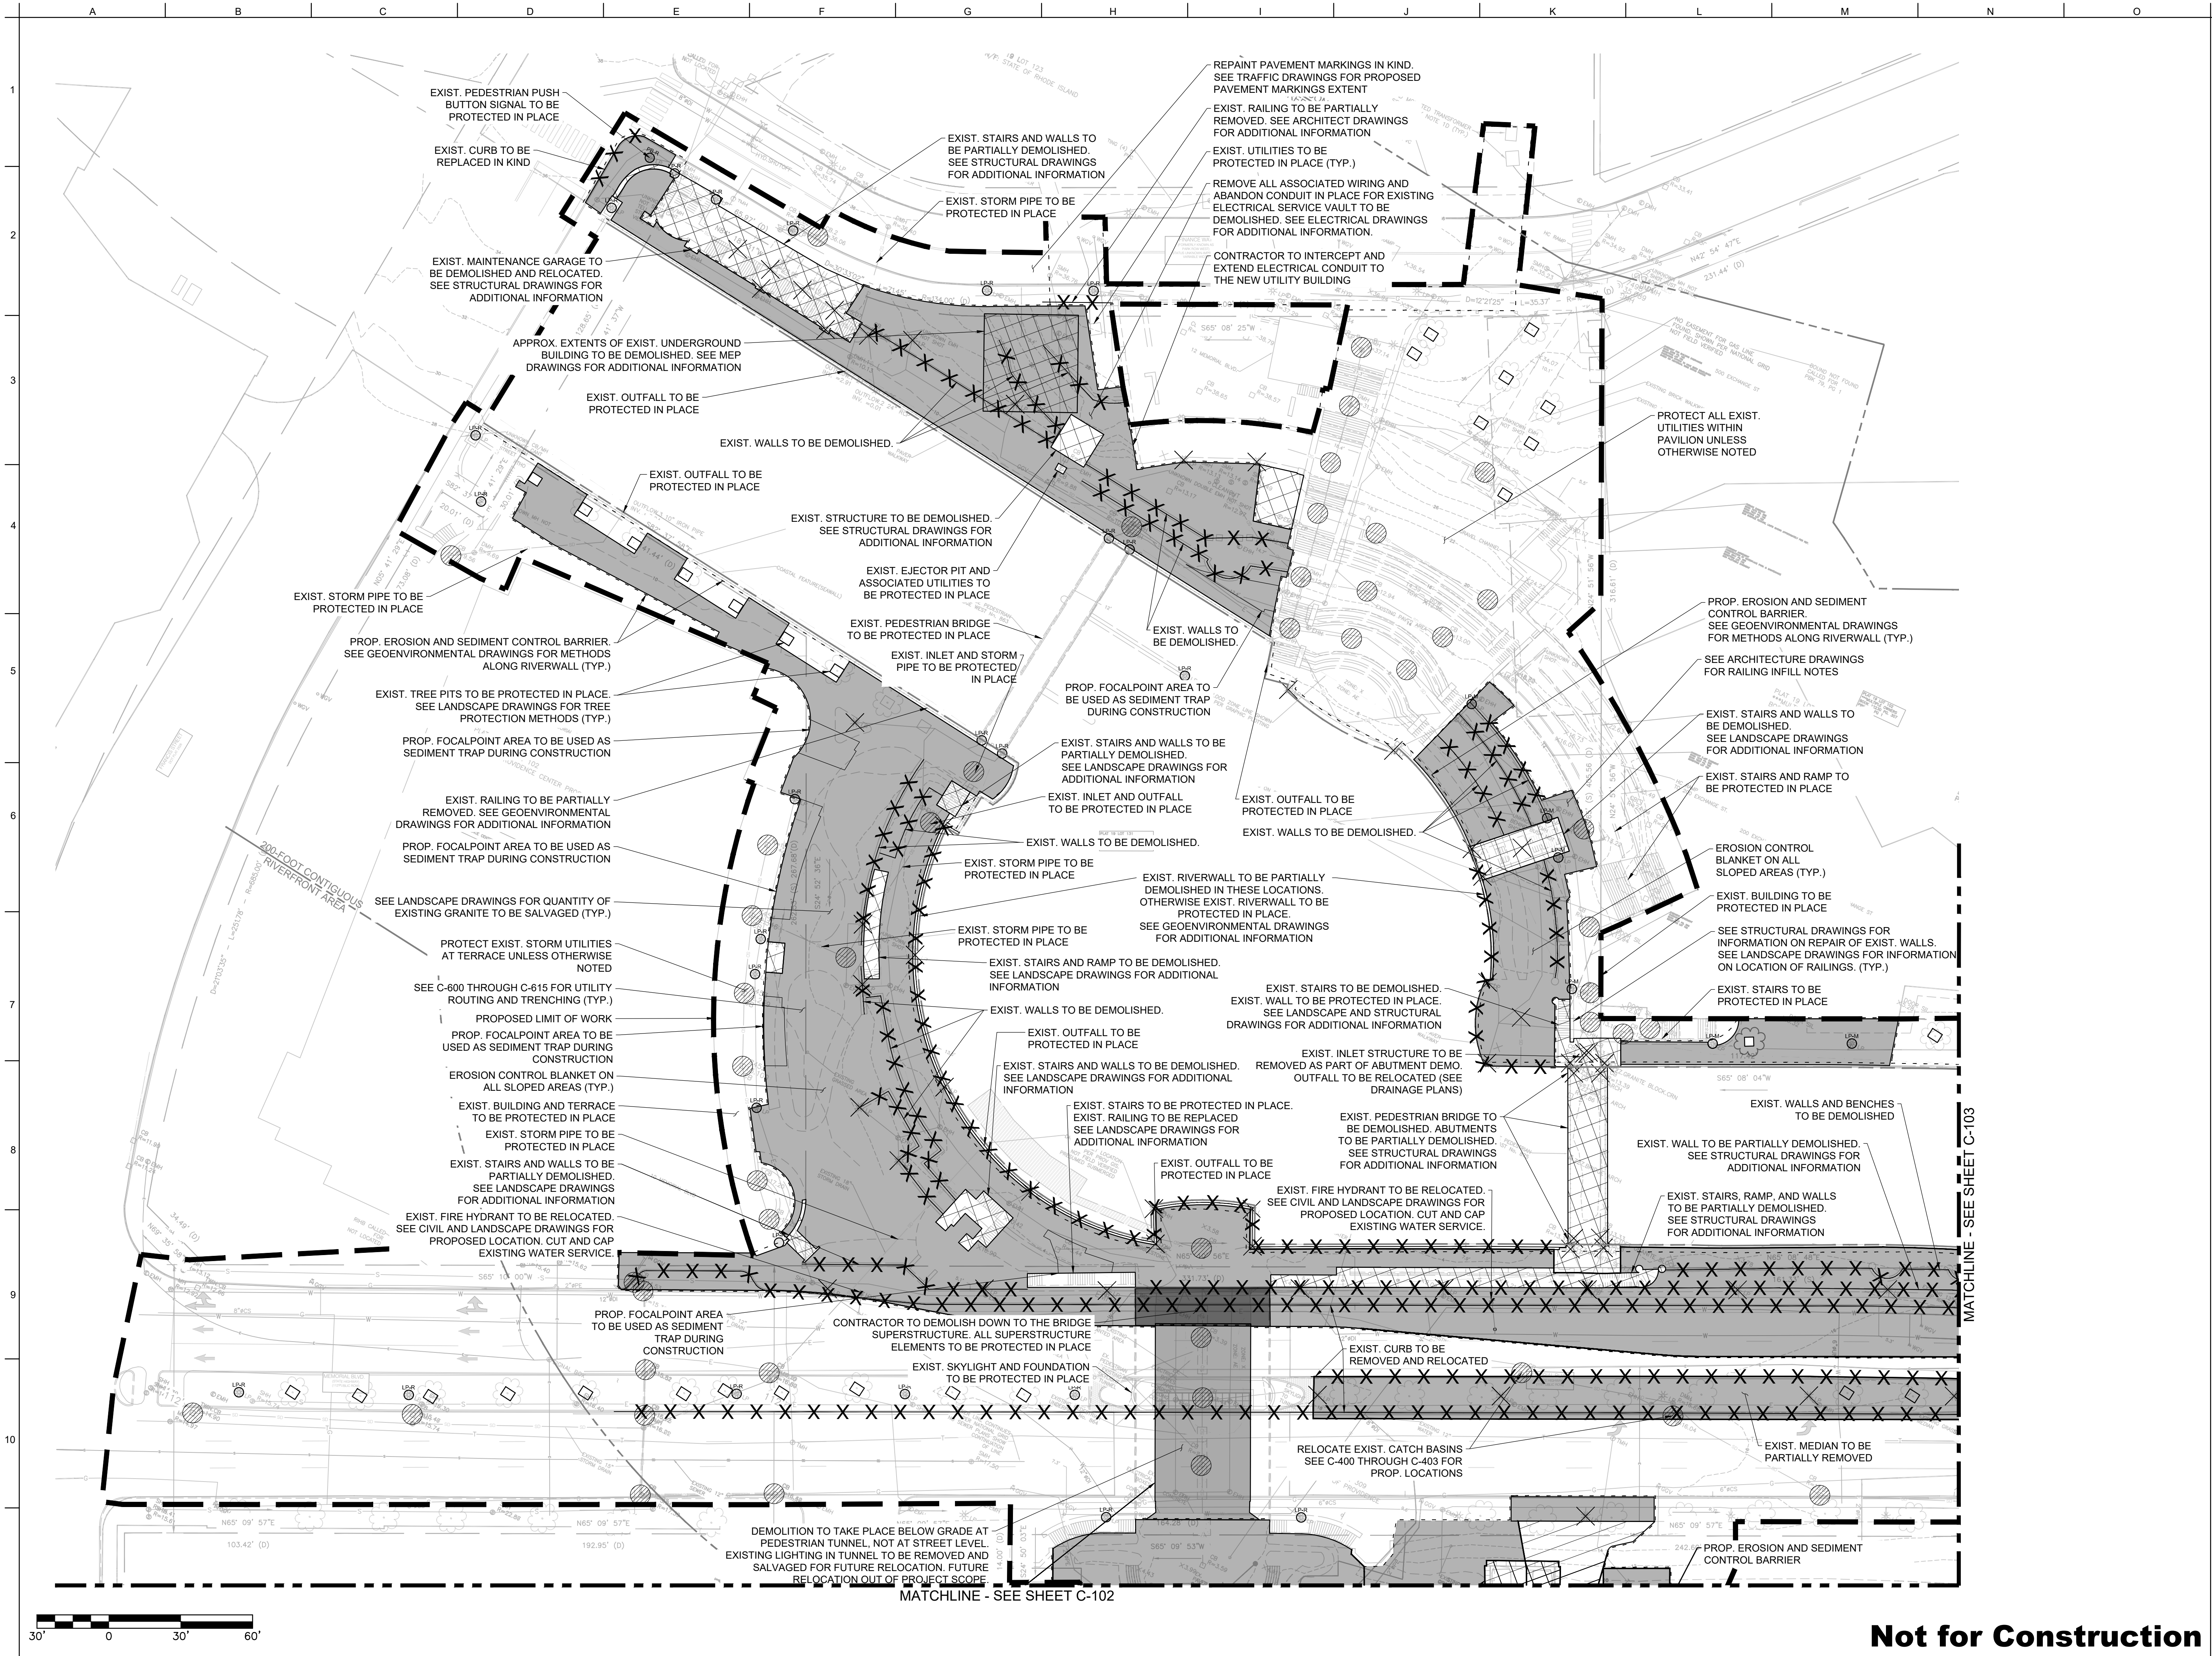

ARUP

Arup US, Inc.
60 State Street
Boston MA 02109
T 617 864 2987
www.arup.com

Project Lead
Civil Engineering
Bridge Engineering
Structural Engineering
Electrical Engineering
Security
Lighting
Public Realm Technology
Fire Life Safety/Code
Fire Alarm
Mechanical Engineering
Plumbing Engineering
Fire Protection

Stephen Stimson Associates Landscape Architects, Inc.
Landscape Architecture
Cambridge, MA

In-form Studio
Architecture
Northville, MI

Vanasse Hangen Brustlin, Inc.
Traffic Engineering

RMA Environmental
Geoenvironmental Engineering
Marine Structures Engineering

Inter-Fluve, Inc.
Marine / Wetland Ecology

Narragansett Engineering, Inc.
Surveying
Portsmouth, RI

Issue	Date	Description
Client		
Providence Department of Planning and Development		
Project Title		
PROVIDENCE RIVERWALK RESILIENCE Riverwalk and Waterplace Park Providence, RI		
Key Plan		
Stamp		
6/5/2026 B. DEREK ANDERSON No. 15235 REGISTERED PROFESSIONAL ENGINEER CIVIL		
Drawing Name		
CIVIL DEMOLITION & EROSION CONTROL PLAN WATERPLACE PARK		
Project Phase		
90% DESIGN		
Disg	Drw	Chkd
RAS	RAS	ABR
Arup Job No.		Revision
303313-00		0
Drawing Number	Date	
C-101	05/01/2026	




Do not scale

Arup US, Inc

Drawing Number	Date
C-102	05/01/2026



Project Phase		90% DESIGN	
Dsg RAS	Drw RAS	Chkd ABR	Scale at ARCH D 1"=30'
Anup Job No 303313-00			Revision 0
Drawing Number C-103			Date 05/01/2026

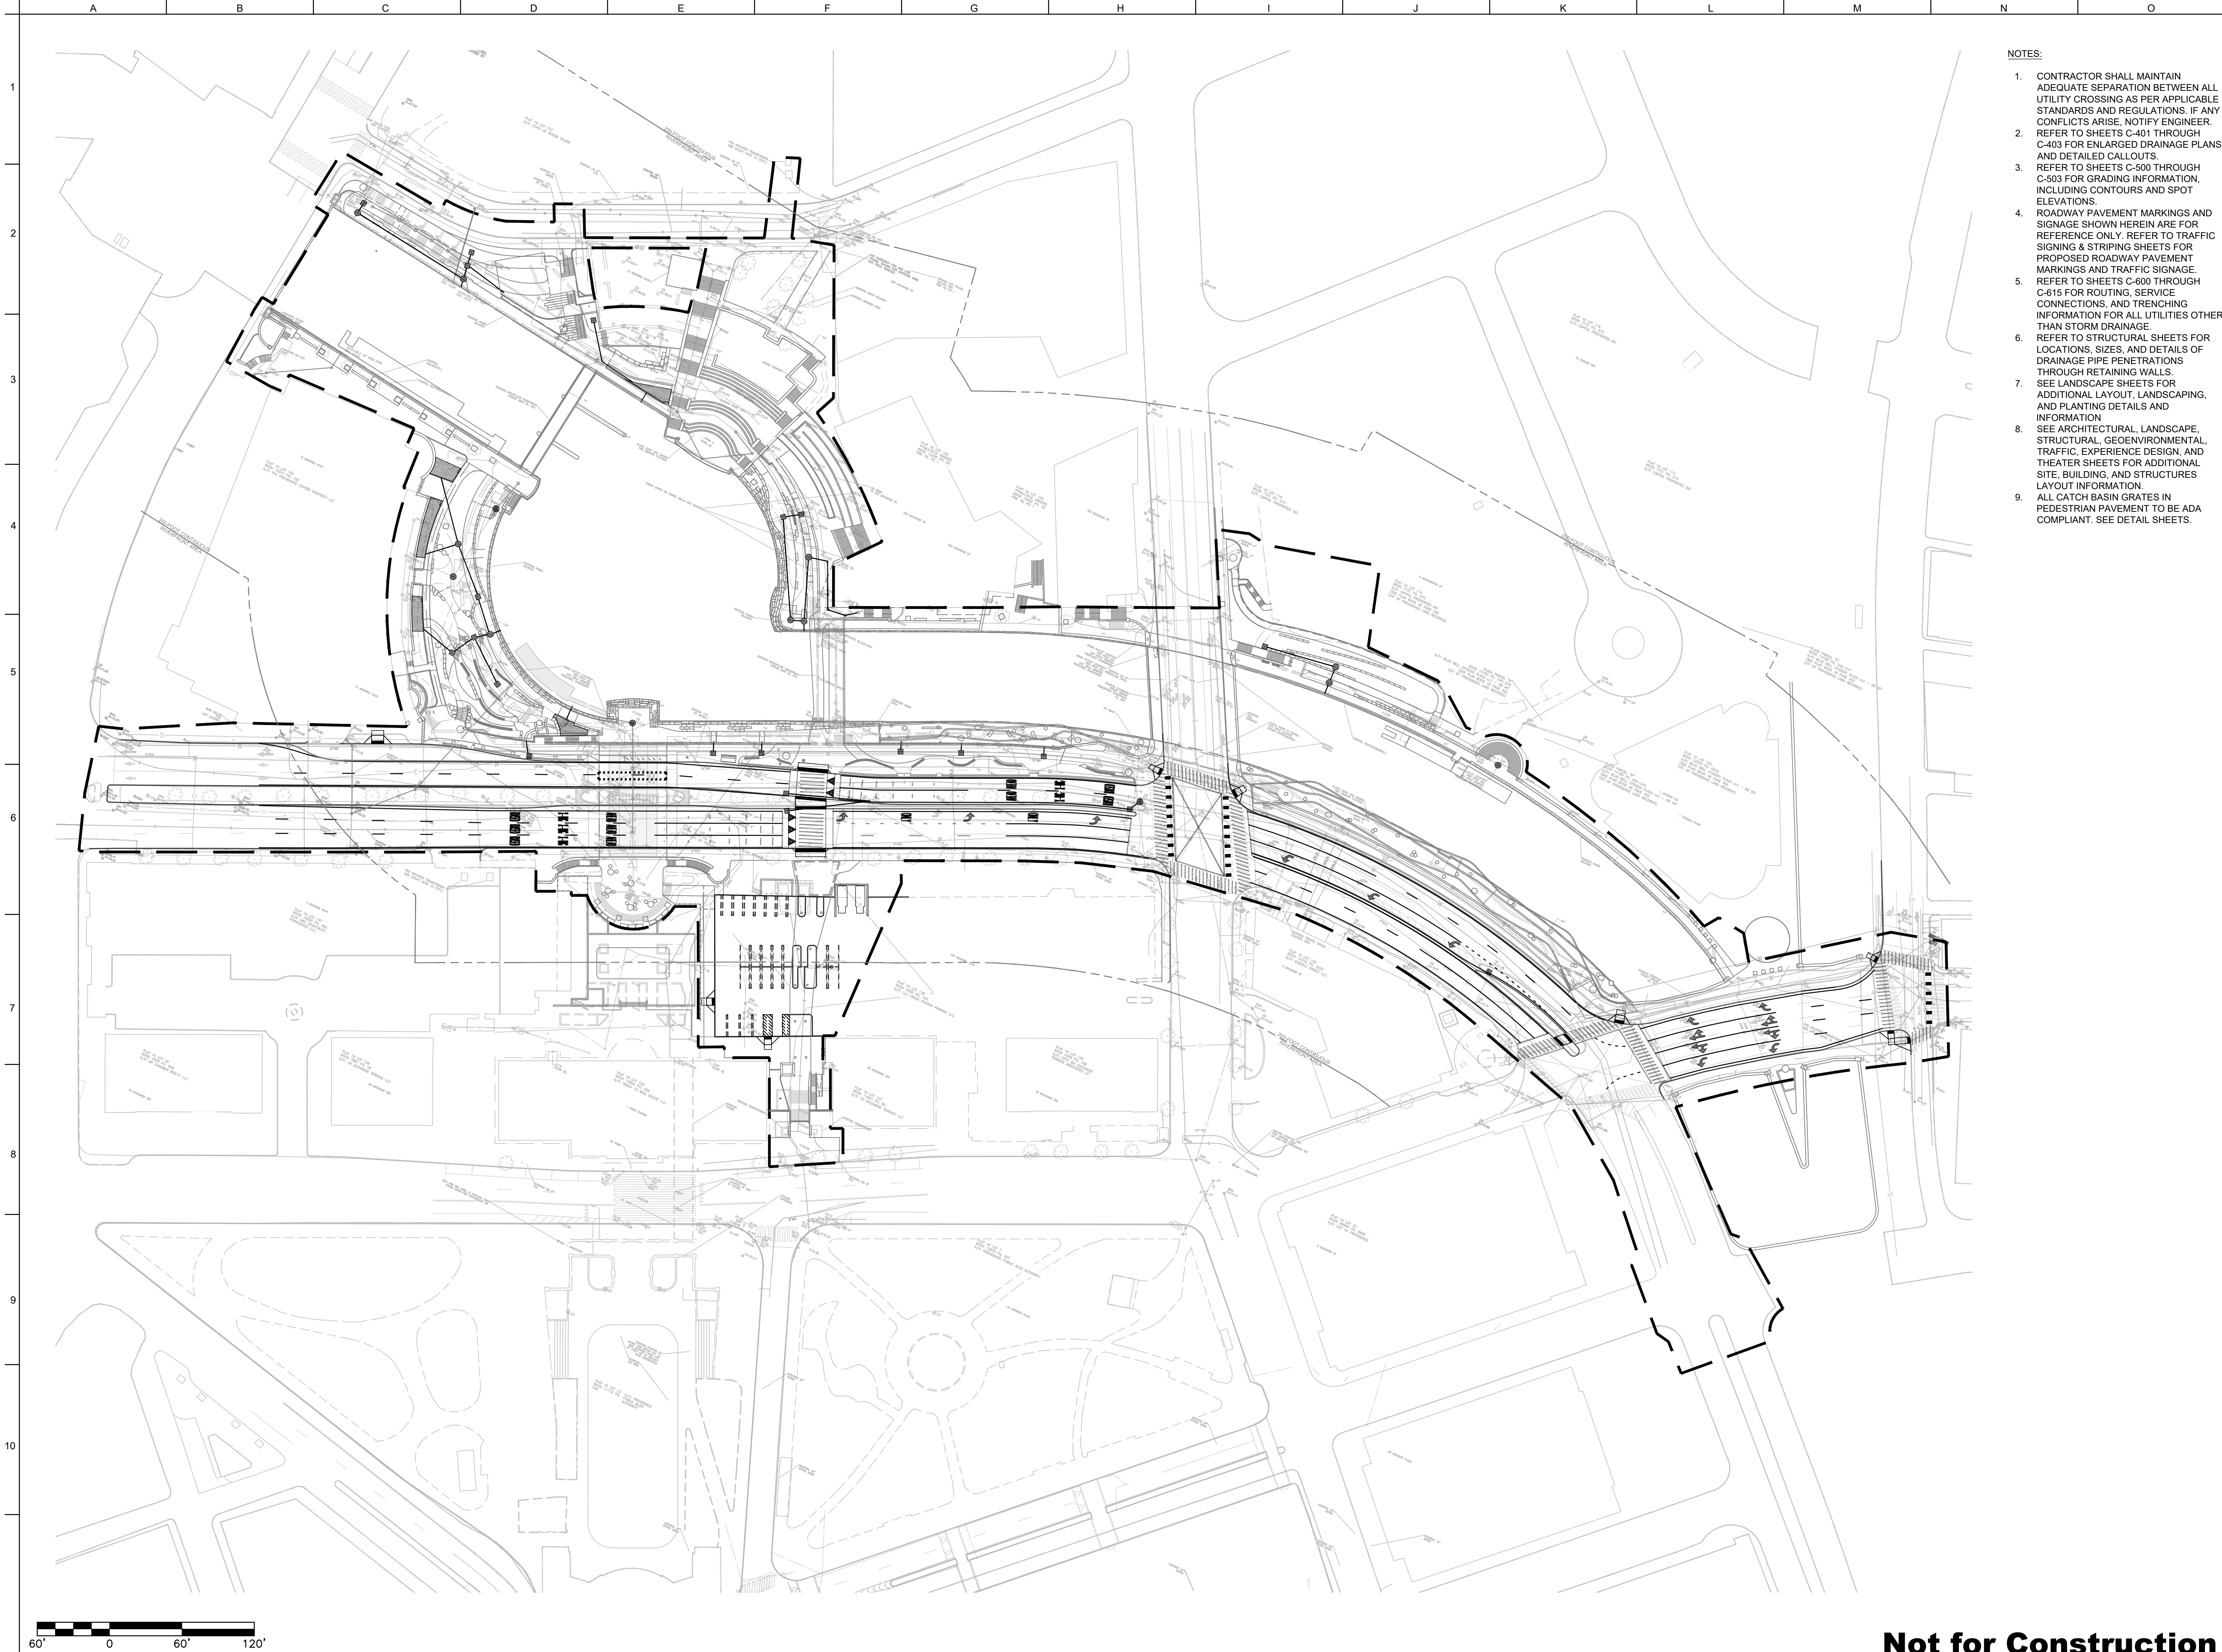

NOTES:

1. CONTRACTOR SHALL MAINTAIN ADEQUATE SEPARATION BETWEEN ALL UTILITY CROSSING AS PER APPLICABLE STANDARDS AND REGULATIONS. IF ANY CONFLICTS ARISE, NOTIFY ENGINEER. REFER TO SHEETS C-401 THROUGH C-403 FOR ENLARGED DRAINAGE PLANS AND DETAILED CALLOUTS.
2. REFER TO SHEETS C-500 THROUGH C-503 FOR GRADING INFORMATION, INCLUDING CONTOURS AND SPOT ELEVATIONS.
3. ROADWAY PAVEMENT MARKINGS AND SIGNAGE SHOWN HEREIN ARE FOR REFERENCE ONLY. REFER TO TRAFFIC SIGNING & STRIPING SHEETS FOR PROPOSED ROADWAY PAVEMENT MARKINGS AND TRAFFIC SIGNAGE. REFER TO SHEETS C-600 THROUGH C-615 FOR ROUTING, SERVICE CONNECTIONS, AND TRENCHING INFORMATION FOR ALL UTILITIES OTHER THAN STORM DRAINAGE.
4. REFER TO STRUCTURAL SHEETS FOR LOCATIONS, SIZES, AND DETAILS OF DRAINAGE PIPE PENETRATIONS THROUGH RETAINING WALLS.
5. SEE LANDSCAPE SHEETS FOR ADDITIONAL LAYOUT, LANDSCAPING, AND PLANTING DETAILS AND INFORMATION.
6. SEE ARCHITECTURAL, LANDSCAPE, STRUCTURAL, GEOENVIRONMENTAL, TRAFFIC, EXPERIENCE DESIGN, AND THEATER SHEETS FOR ADDITIONAL SITE, BUILDING, AND STRUCTURES LAYOUT INFORMATION.
7. ALL CATCH BASIN GRATES IN PEDESTRIAN PAVEMENT TO BE ADA COMPLIANT. SEE DETAIL SHEETS.

ARUP

Arup US, Inc.
60 State Street
Boston MA 02109
T 617 864 2987
www.arup.com

Project Lead
Civil Engineering
Bridge Engineering
Structural Engineering
Electrical Engineering
Security
Lighting
Public Realm Technology
Fire Life Safety/Code
Fire Alarm
Mechanical Engineering
Plumbing Engineering
Fire Protection

Stephen Stimson Associates Landscape Architects, Inc.
Landscape Architecture
Cambridge, MA

In-form Studio
Architecture
Northville, MI

Vanasse Hangen Brustlin, Inc.
Traffic Engineering

RMA Environmental
Geoenvironmental Engineering
Marine Structures Engineering

Inter-Fluve, Inc.
Marine / Wetland Ecology

Narragansett Engineering, Inc.
Surveying
Portsmouth, RI

Issue	Date	Description
-------	------	-------------


Client

Providence Department of Planning
and Development


Project Title

PROVIDENCE RIVERWALK
RESILIENCE
Riverwalk and Waterplace Park
Providence, RI

Key Plan

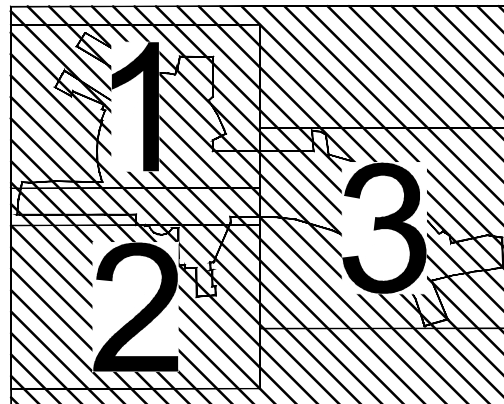

Stamp

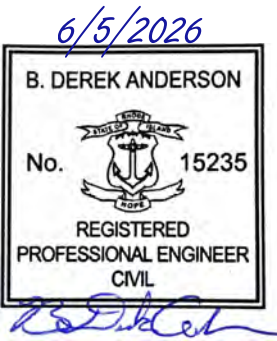


Drawing Name

CIVIL
DRAINAGE PLAN
OVERALL SITE

Project Phase 90% DESIGN

Disc	Drw	Chkd	Scale at
RK	RK	ABR	ARCH D 1"=60'
Arup Job No.			Revision
303313-00			0
Drawing Number			Date
C-400			05/01/2026

Not for Construction

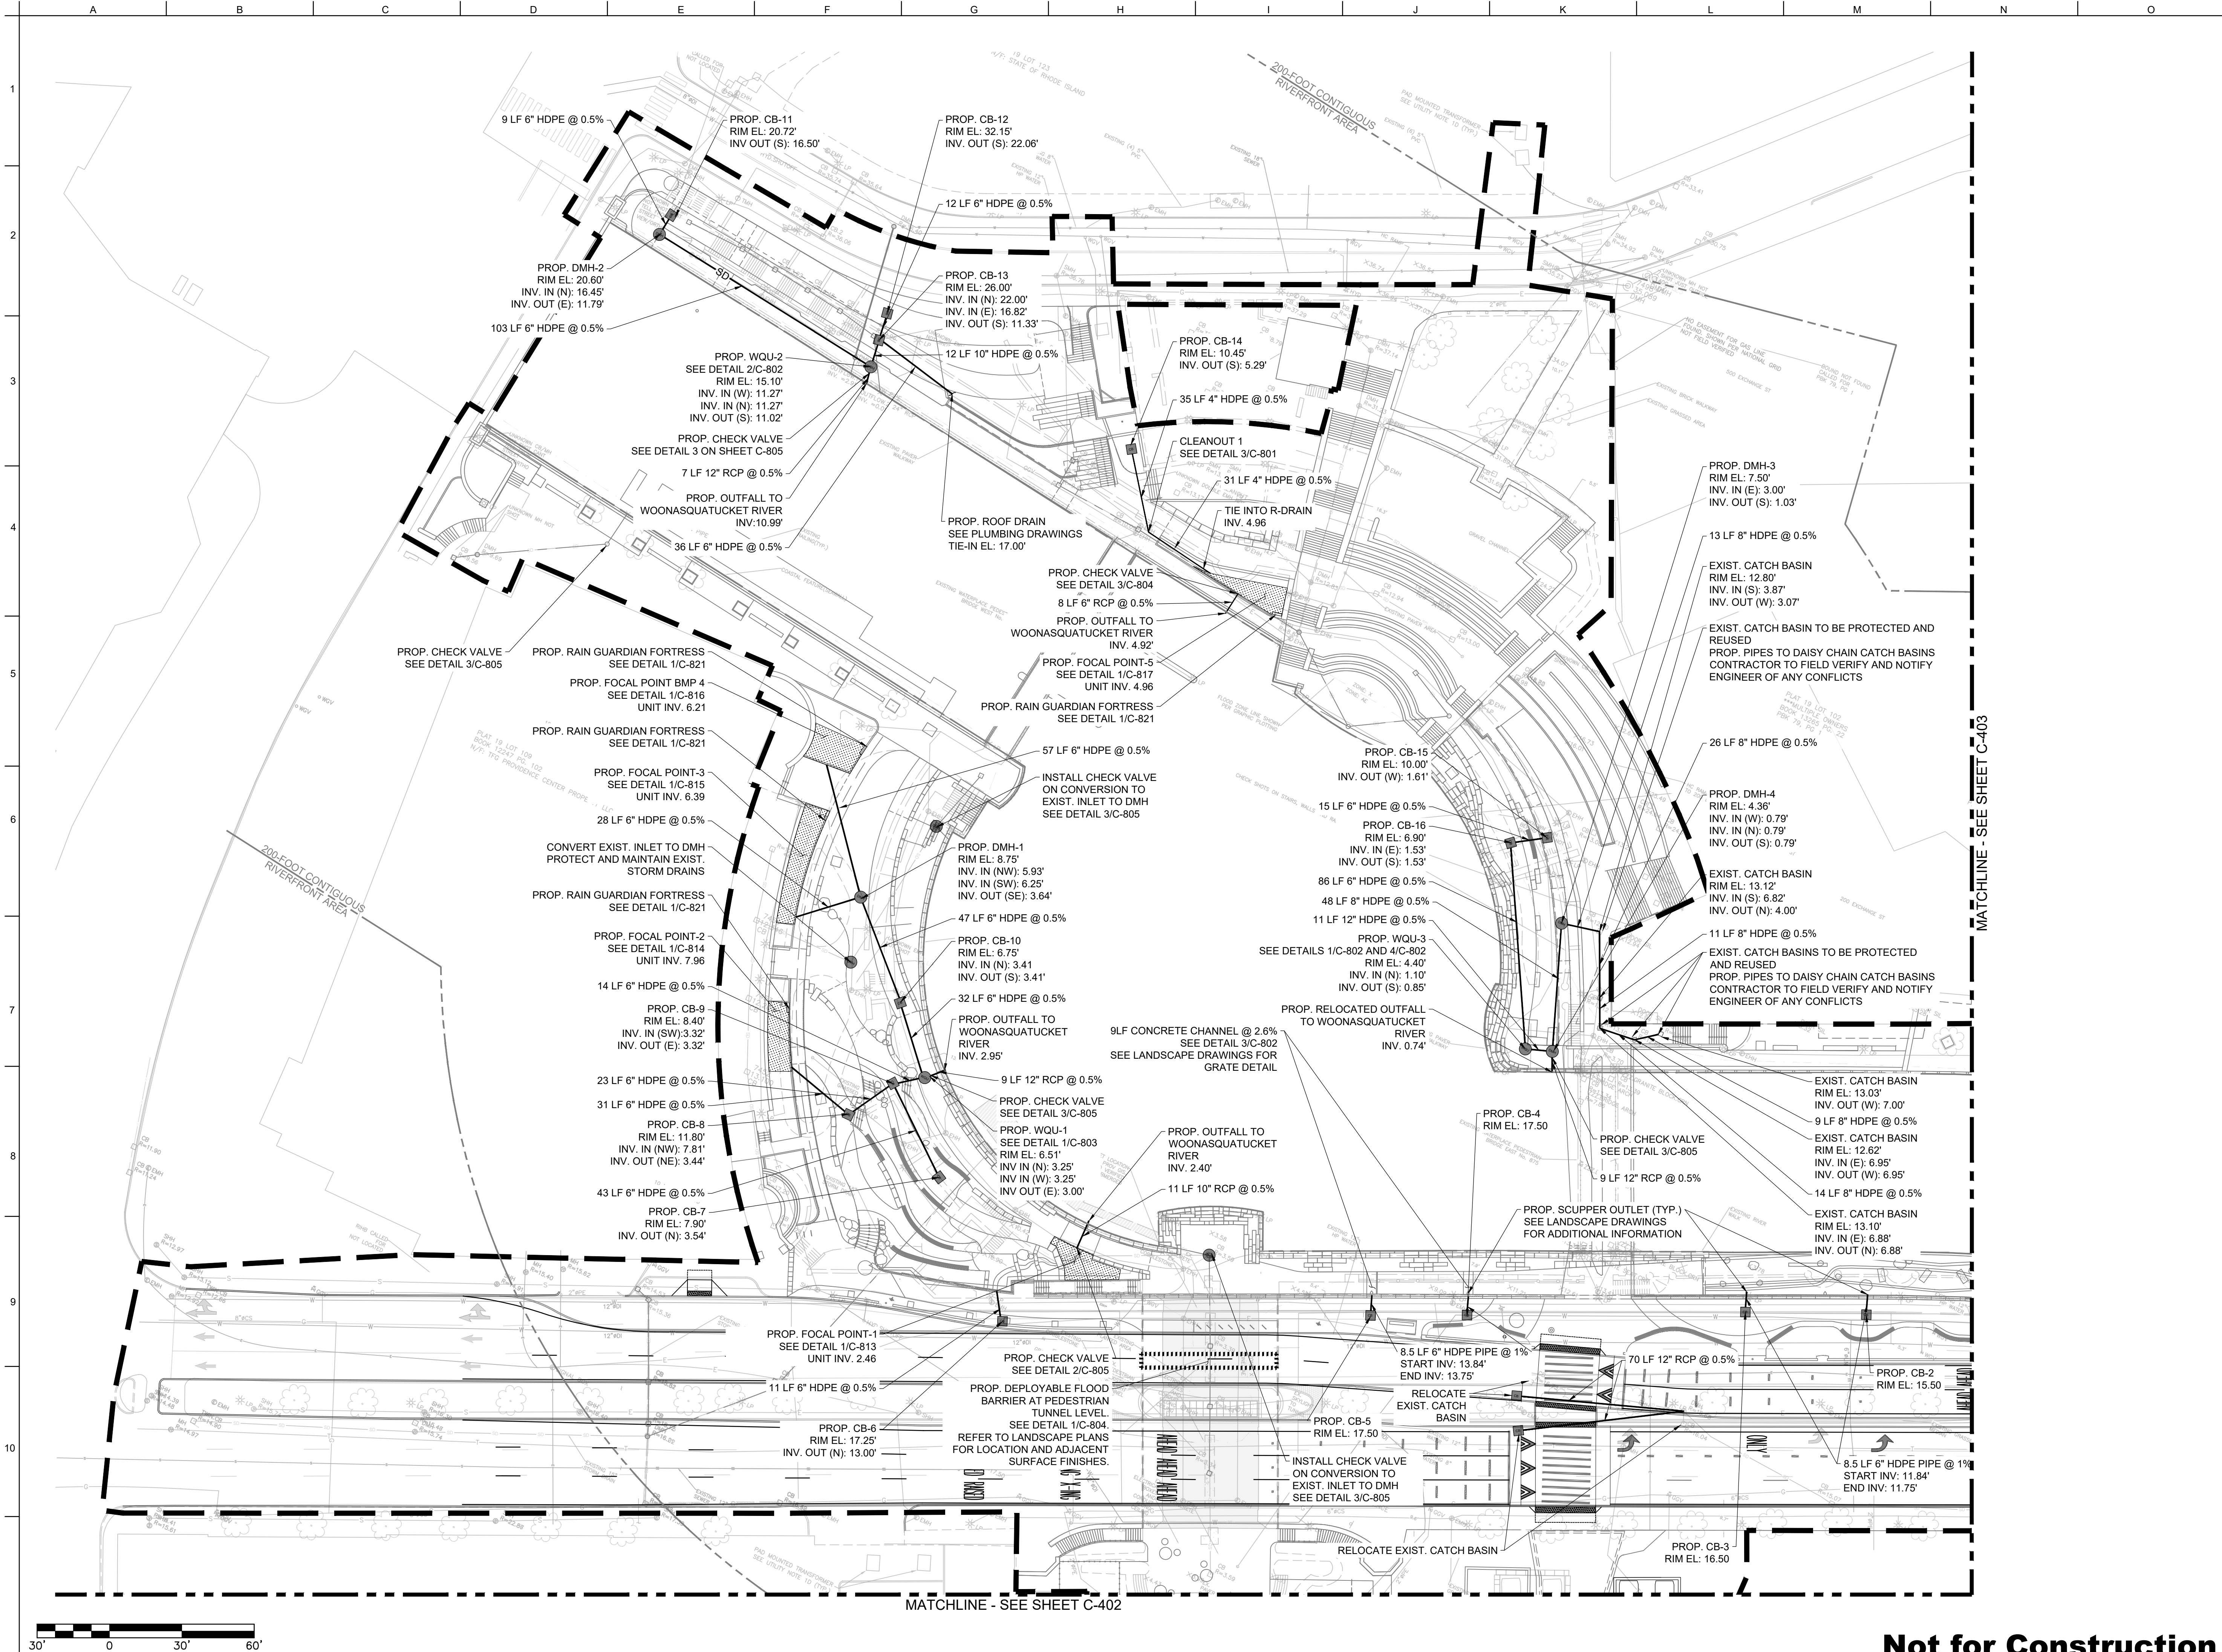

ARUP

Arup US, Inc.
60 State Street
Boston MA 02109
T 617 864 2987
www.arup.com

Project Lead
Civil Engineering
Bridge Engineering
Structural Engineering
Electrical Engineering
Security
Lighting
Public Realm Technology
Fire Life Safety/Code
Fire Alarm
Mechanical Engineering
Plumbing Engineering
Fire Protection

Stephen Stimson Associates Landscape Architects, Inc.
Landscape Architecture
Cambridge, MA

In-form Studio
Architecture
Northville, MI

Vanasse Hangen Brustlin, Inc.
Traffic Engineering


RMA Environmental
Geoenvironmental Engineering
Marine Structures Engineering


Inter-Fluve, Inc.
Marine / Wetland Ecology

Narragansett Engineering, Inc.
Surveying
Portsmouth, RI

Issue	Date	Description		
Client		Providence Department of Planning and Development		
Project Title		PROVIDENCE RIVERWALK RESILIENCE Riverwalk and Waterplace Park Providence, RI		
Key Plan				
Stamp				
Drawing Name		CIVIL DRAINAGE PLAN WATERPLACE PARK		
Project Phase		90% DESIGN		
Disg RK	Drw RK	Chkd ABR	Scale at ARCH D	1"=30'
Arup Job No	303313-00	Revision	0	
Drawing Number	C-401	Date	05/01/2026	

Not for Construction

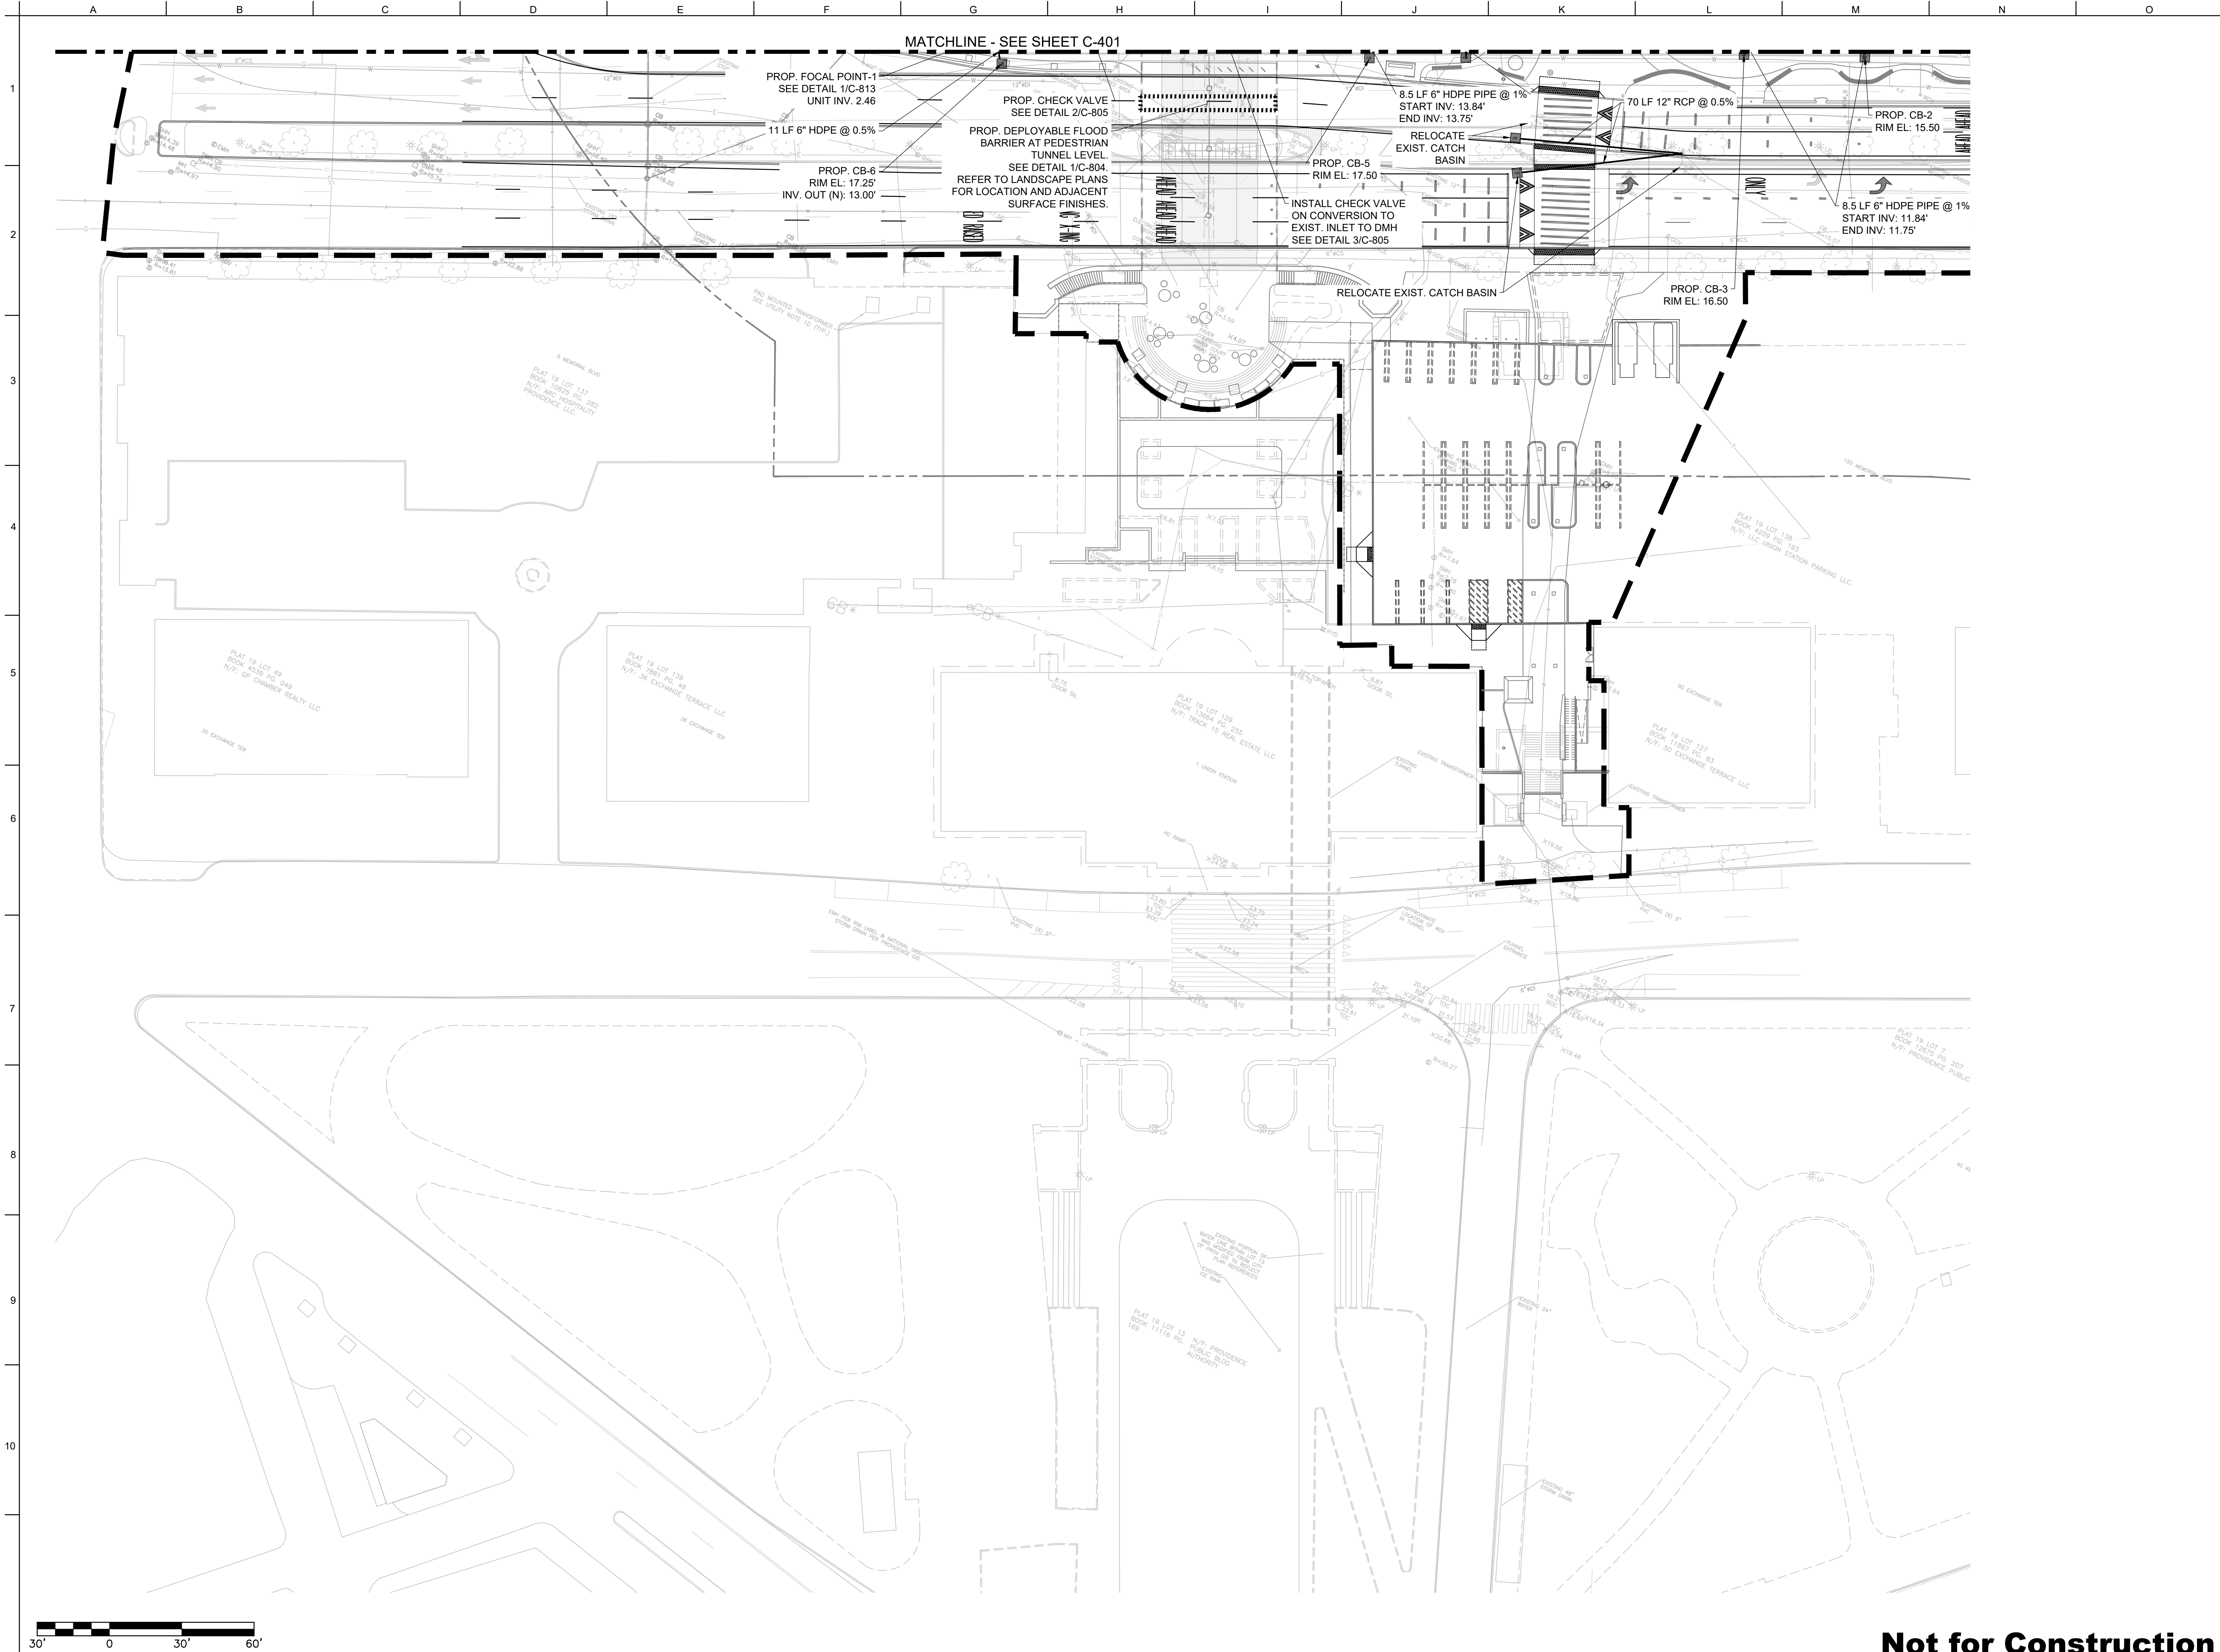

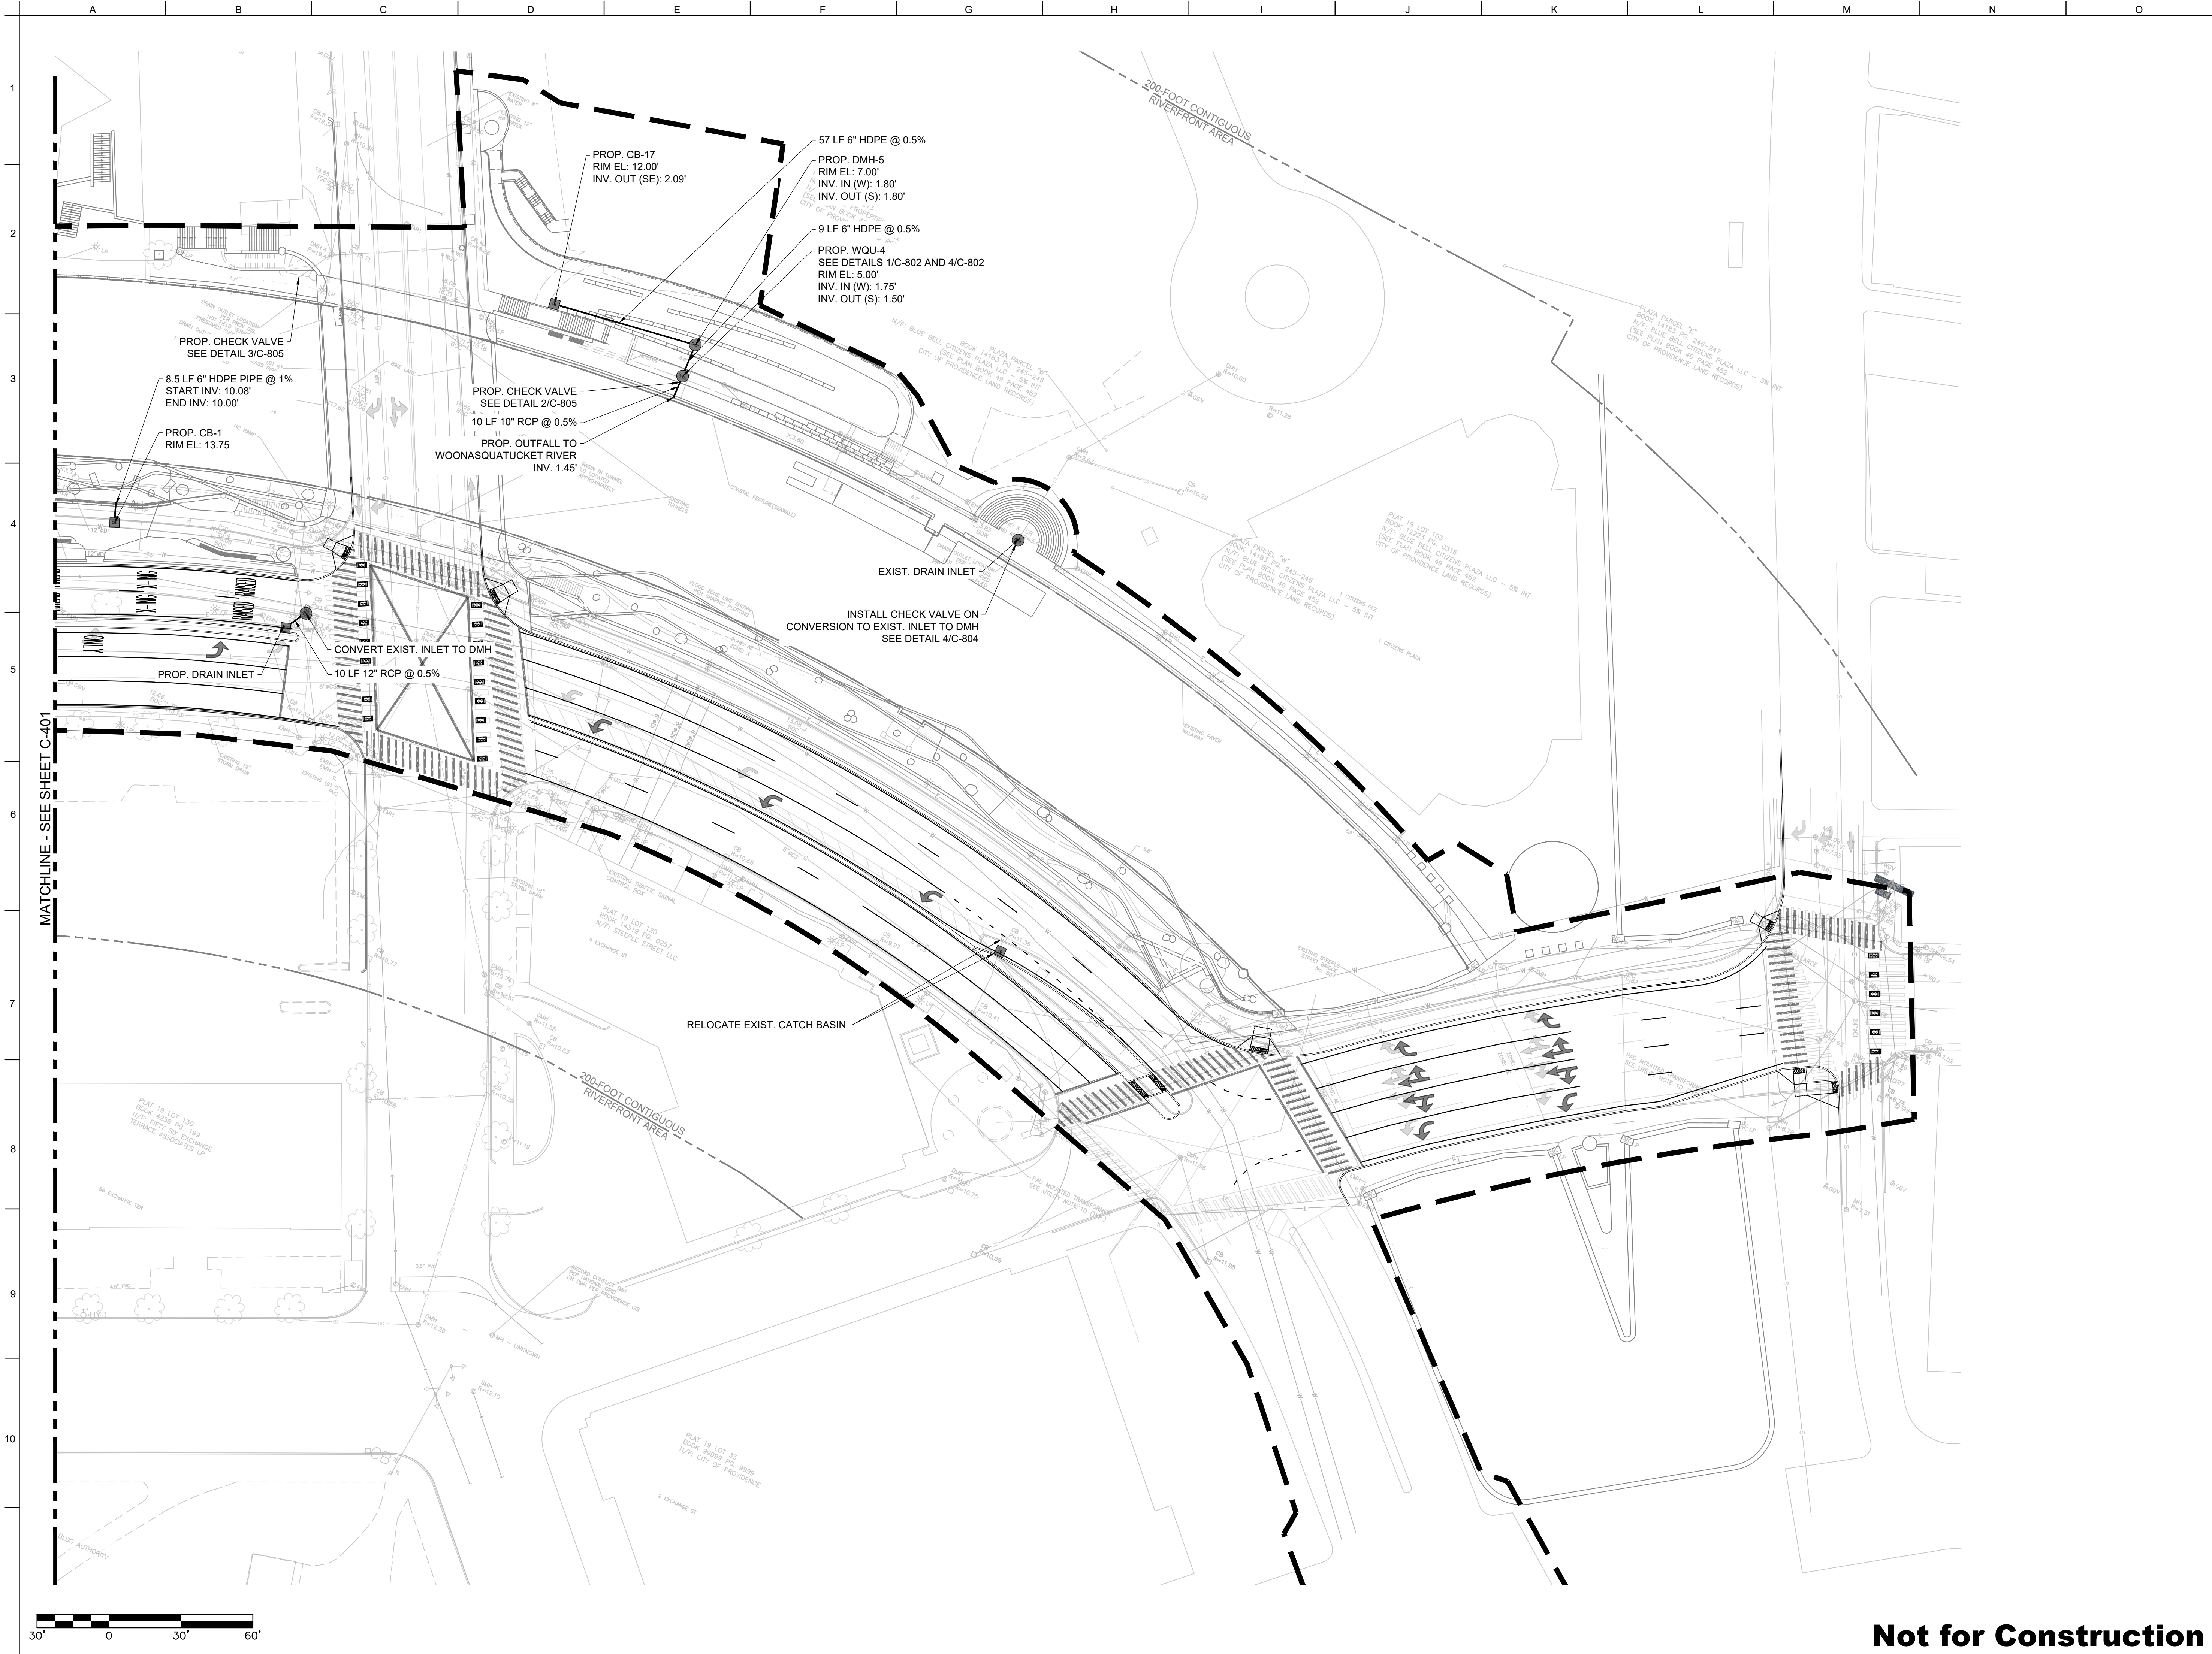

ARUP

Arup US, Inc.
60 State Street
Boston MA 02109
T 617 864 2987
www.arup.com

Project Lead
Civil Engineering
Bridge Engineering
Structural Engineering
Electrical Engineering
Security
Lighting
Public Realm Technology
Fire Life Safety/Code
Fire Alarm
Mechanical Engineering
Plumbing Engineering
Fire Protection

Stephen Stimson Associates Landscape Architects, Inc.
Landscape Architecture
Cambridge, MA

In-form Studio
Architecture
Northville, MI

Vanasse Hangen Brustlin, Inc.
Traffic Engineering

RMA Environmental
Geoenvironmental Engineering
Marine Structures Engineering

Inter-Fluve, Inc.
Marine / Wetland Ecology


Narragansett Engineering, Inc.
Surveying
Portsmouth, RI

Issue	Date	Description
Client		
Providence Department of Planning and Development		
Project Title		
PROVIDENCE RIVERWALK RESILIENCE Riverwalk and Waterplace Park Providence, RI		
Key Plan		
Stamp		
6/5/2026 B. DEREK ANDERSON No. 15235 REGISTERED PROFESSIONAL ENGINEER CIVIL		
Drawing Name		
CIVIL DRAINAGE PLAN STEEPLE STREET		
Project Phase		
90% DESIGN		
Disg RK		
Drw RK		
Chkd ABR		
Scale at ARCH D 1"=30'		
Arup Job No.		
303313-00		
Revision		
0		
Drawing Number		
C-403		
Date		
05/01/2026		

Not for Construction

Do not scale

Arup US, Inc.

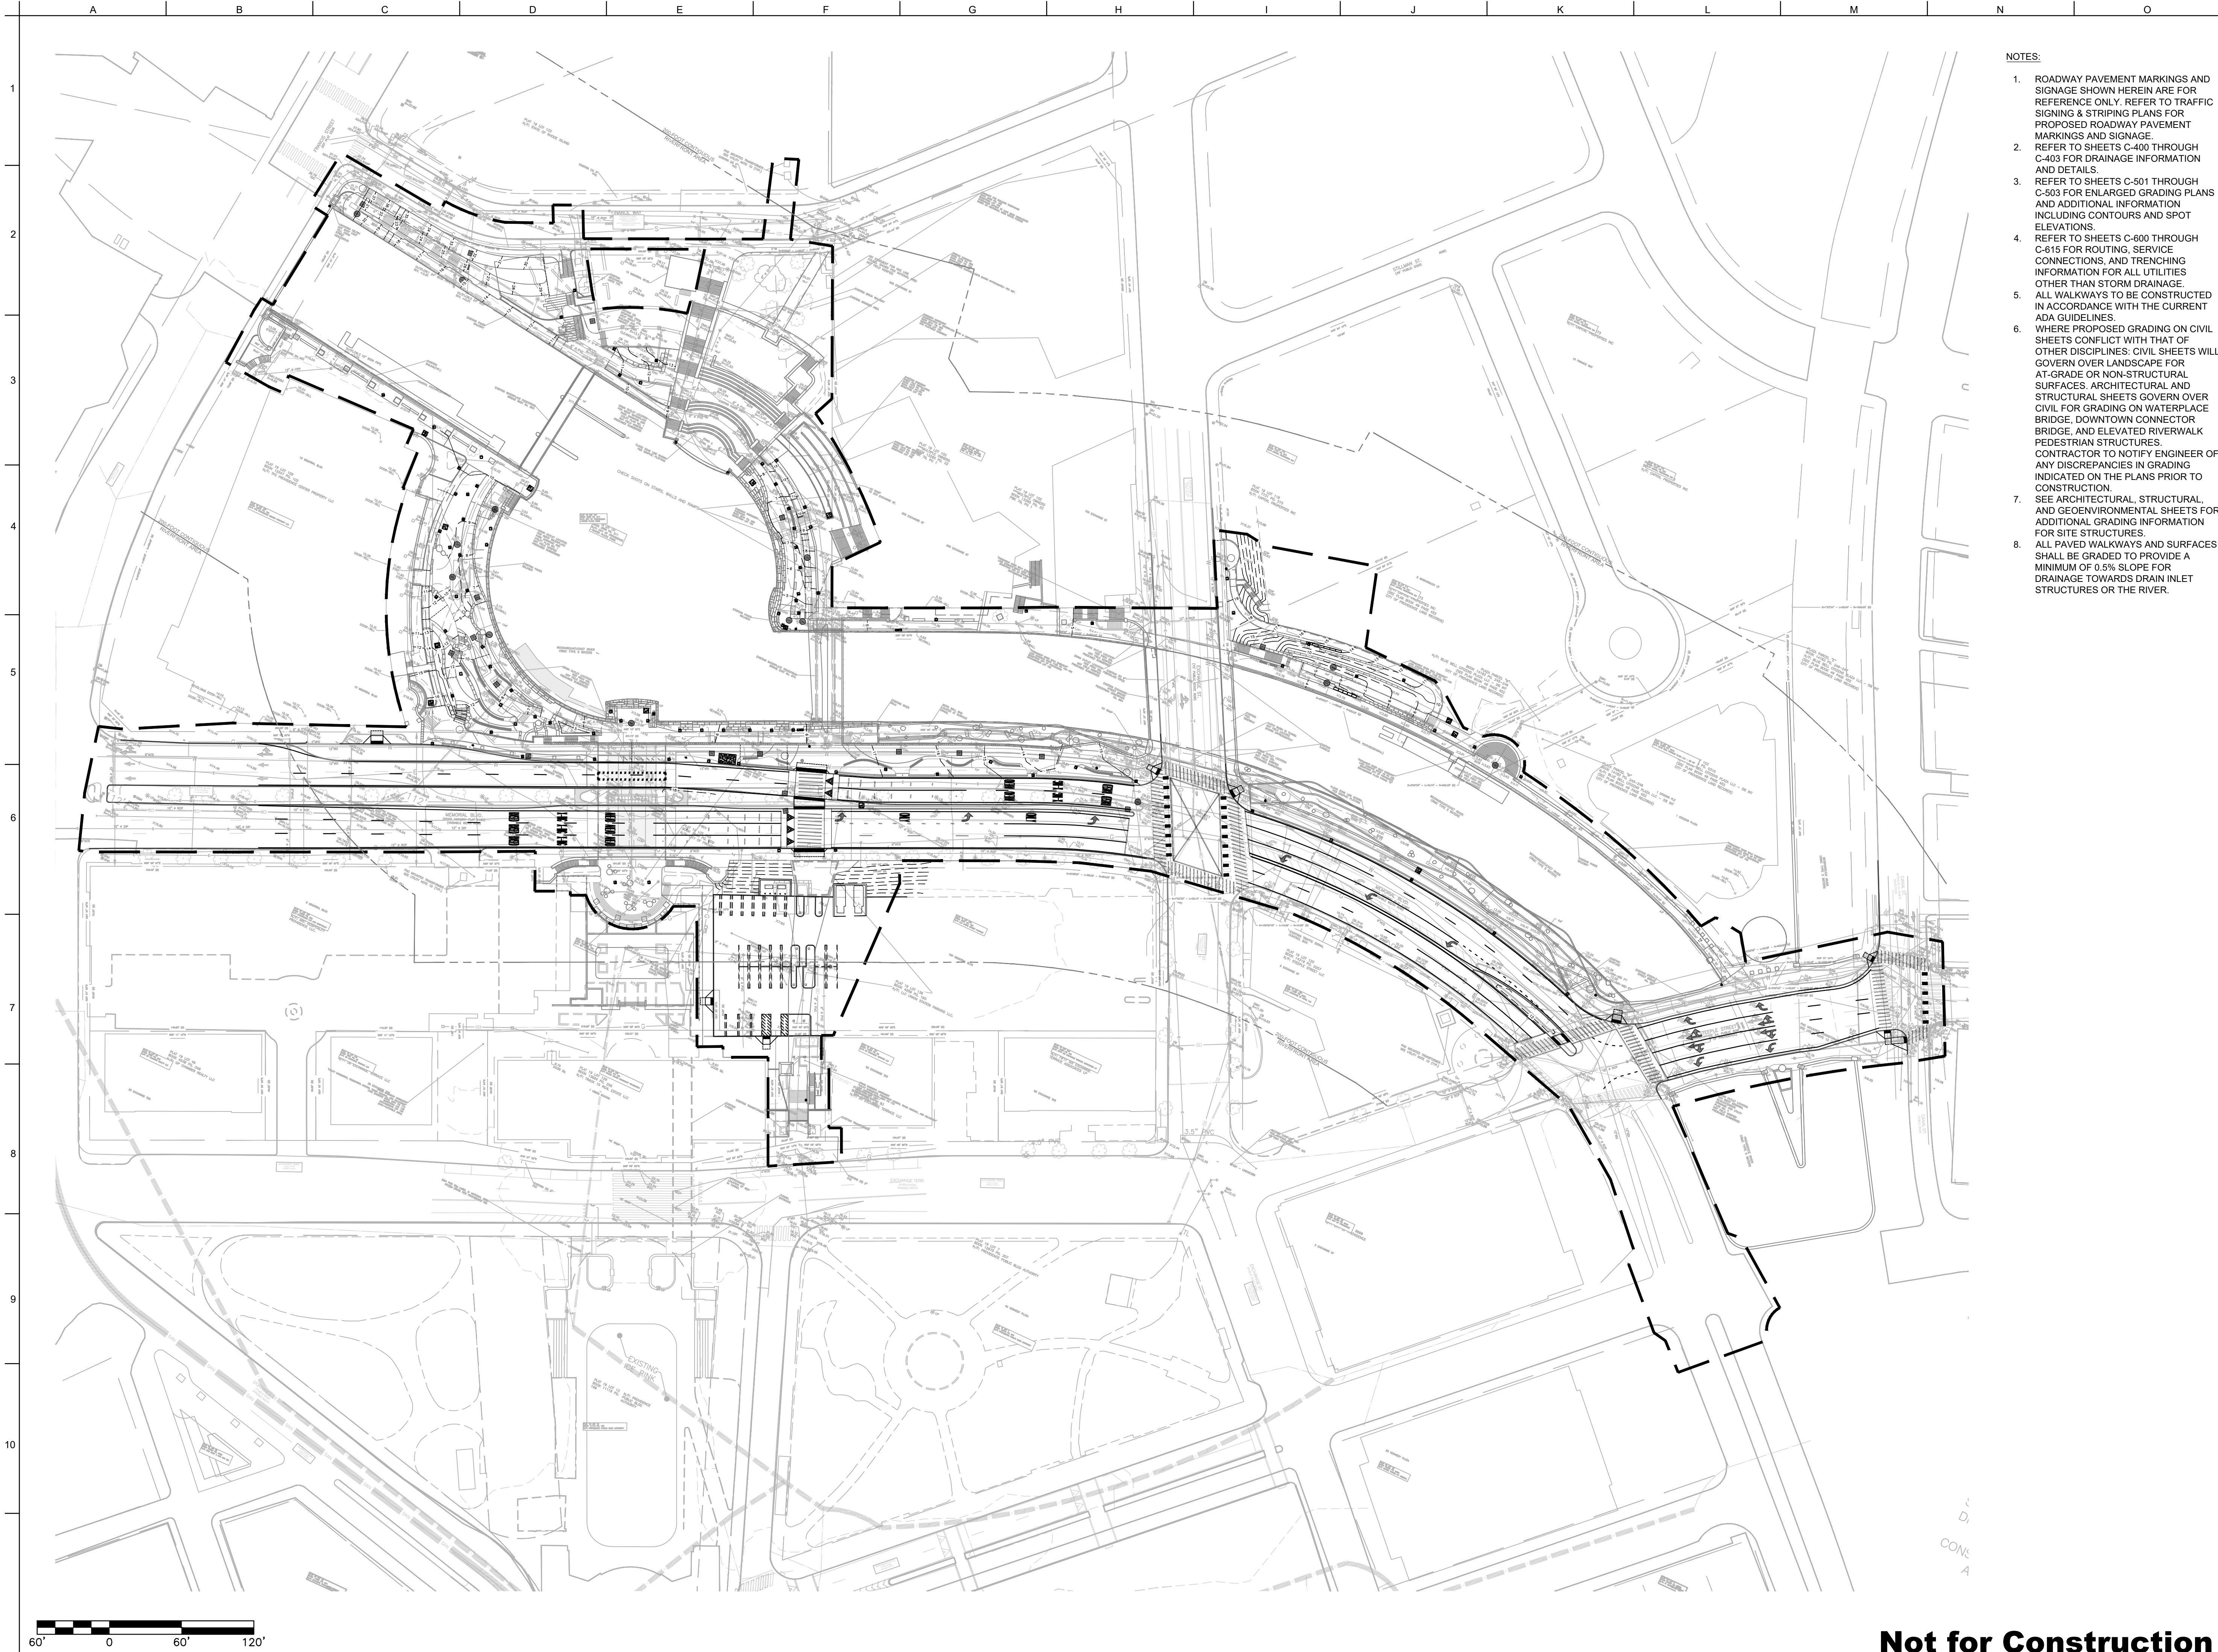

NOTES:

1. ROADWAY PAVEMENT MARKINGS AND SIGNAGE SHOWN HEREIN ARE FOR REFERENCE ONLY. REFER TO TRAFFIC SIGNING & STRIPING PLANS FOR PROPOSED ROADWAY PAVEMENT MARKINGS AND SIGNAGE.
2. REFER TO SHEETS C-400 THROUGH C-403 FOR DRAINAGE INFORMATION AND DETAILS.
3. REFER TO SHEETS C-501 THROUGH C-503 FOR ENLARGED GRADING PLANS AND ADDITIONAL INFORMATION INCLUDING CONTOURS AND SPOT ELEVATIONS.
4. REFER TO SHEETS C-600 THROUGH C-615 FOR ROUTING, SERVICE CONNECTIONS, AND TRENCHING INFORMATION FOR ALL UTILITIES OTHER THAN STORM DRAINAGE.
5. ALL WALKWAYS TO BE CONSTRUCTED IN ACCORDANCE WITH THE CURRENT ADA GUIDELINES.
6. WHERE PROPOSED GRADING ON CIVIL SHEETS CONFLICT WITH THAT OF OTHER DISCIPLINES, CIVIL SHEETS WILL GOVERN OVER LANDSCAPE FOR AT-GRADE OR NON-STRUCTURAL SURFACES. ARCHITECTURAL AND STRUCTURAL SHEETS GOVERN OVER CIVIL FOR GRADING ON WATERPLACE BRIDGE, DOWNTOWN CONNECTOR BRIDGE, AND ELEVATED RIVERWALK PEDESTRIAN STRUCTURES. CONTRACTOR TO NOTIFY ENGINEER OF ANY DISCREPANCIES IN GRADING INDICATED ON THE PLANS PRIOR TO CONSTRUCTION.
7. SEE ARCHITECTURAL, STRUCTURAL, AND GEOENVIRONMENTAL SHEETS FOR ADDITIONAL GRADING INFORMATION FOR SITE STRUCTURES.
8. ALL PAVED WALKWAYS AND SURFACES SHALL BE GRADED TO PROVIDE A MINIMUM OF 0.5% SLOPE FOR DRAINAGE TOWARDS DRAIN INLET STRUCTURES OR THE RIVER.

ARUP

Arup US, Inc.
60 State Street
Boston MA 02109
T 617 864 2987
www.arup.com

Project Lead
Civil Engineering
Bridge Engineering
Structural Engineering
Electrical Engineering
Security
Lighting
Public Realm Technology
Fire Life Safety/Code
Fire Alarm
Mechanical Engineering
Plumbing Engineering
Fire Protection

Stephen Stimson Associates Landscape Architects, Inc.
Landscape Architecture
Cambridge, MA

In-form Studio
Architecture
Northville, MI

Vanasse Hangen Brustlin, Inc.
Traffic Engineering

RMA Environmental
Geoenvironmental Engineering
Marine Structures Engineering

Inter-Fluve, Inc.
Marine / Wetland Ecology

Narragansett Engineering, Inc.
Surveying
Portsmouth, RI

Issue	Date	Description
-------	------	-------------


Client

Providence Department of Planning
and Development


Project Title

PROVIDENCE RIVERWALK
RESILIENCE
Riverwalk and Waterplace Park
Providence, RI

Key Plan

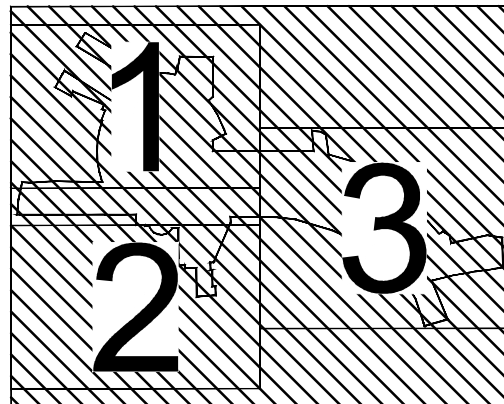

Stamp

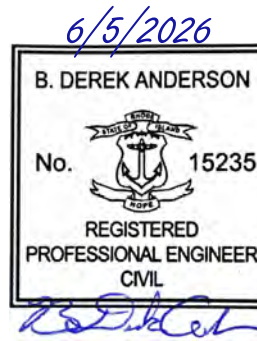


Drawing Name

CIVIL
GRADING PLAN
OVERALL SITE

Project Phase	90% DESIGN			Scale at ARCH D	1"=60'
Disg RK	Drw RK	Chkd ABR	Revision		
Arup Job No. 303313-00			0		
Drawing Number C-500			Date	05/01/2026	

Not for Construction

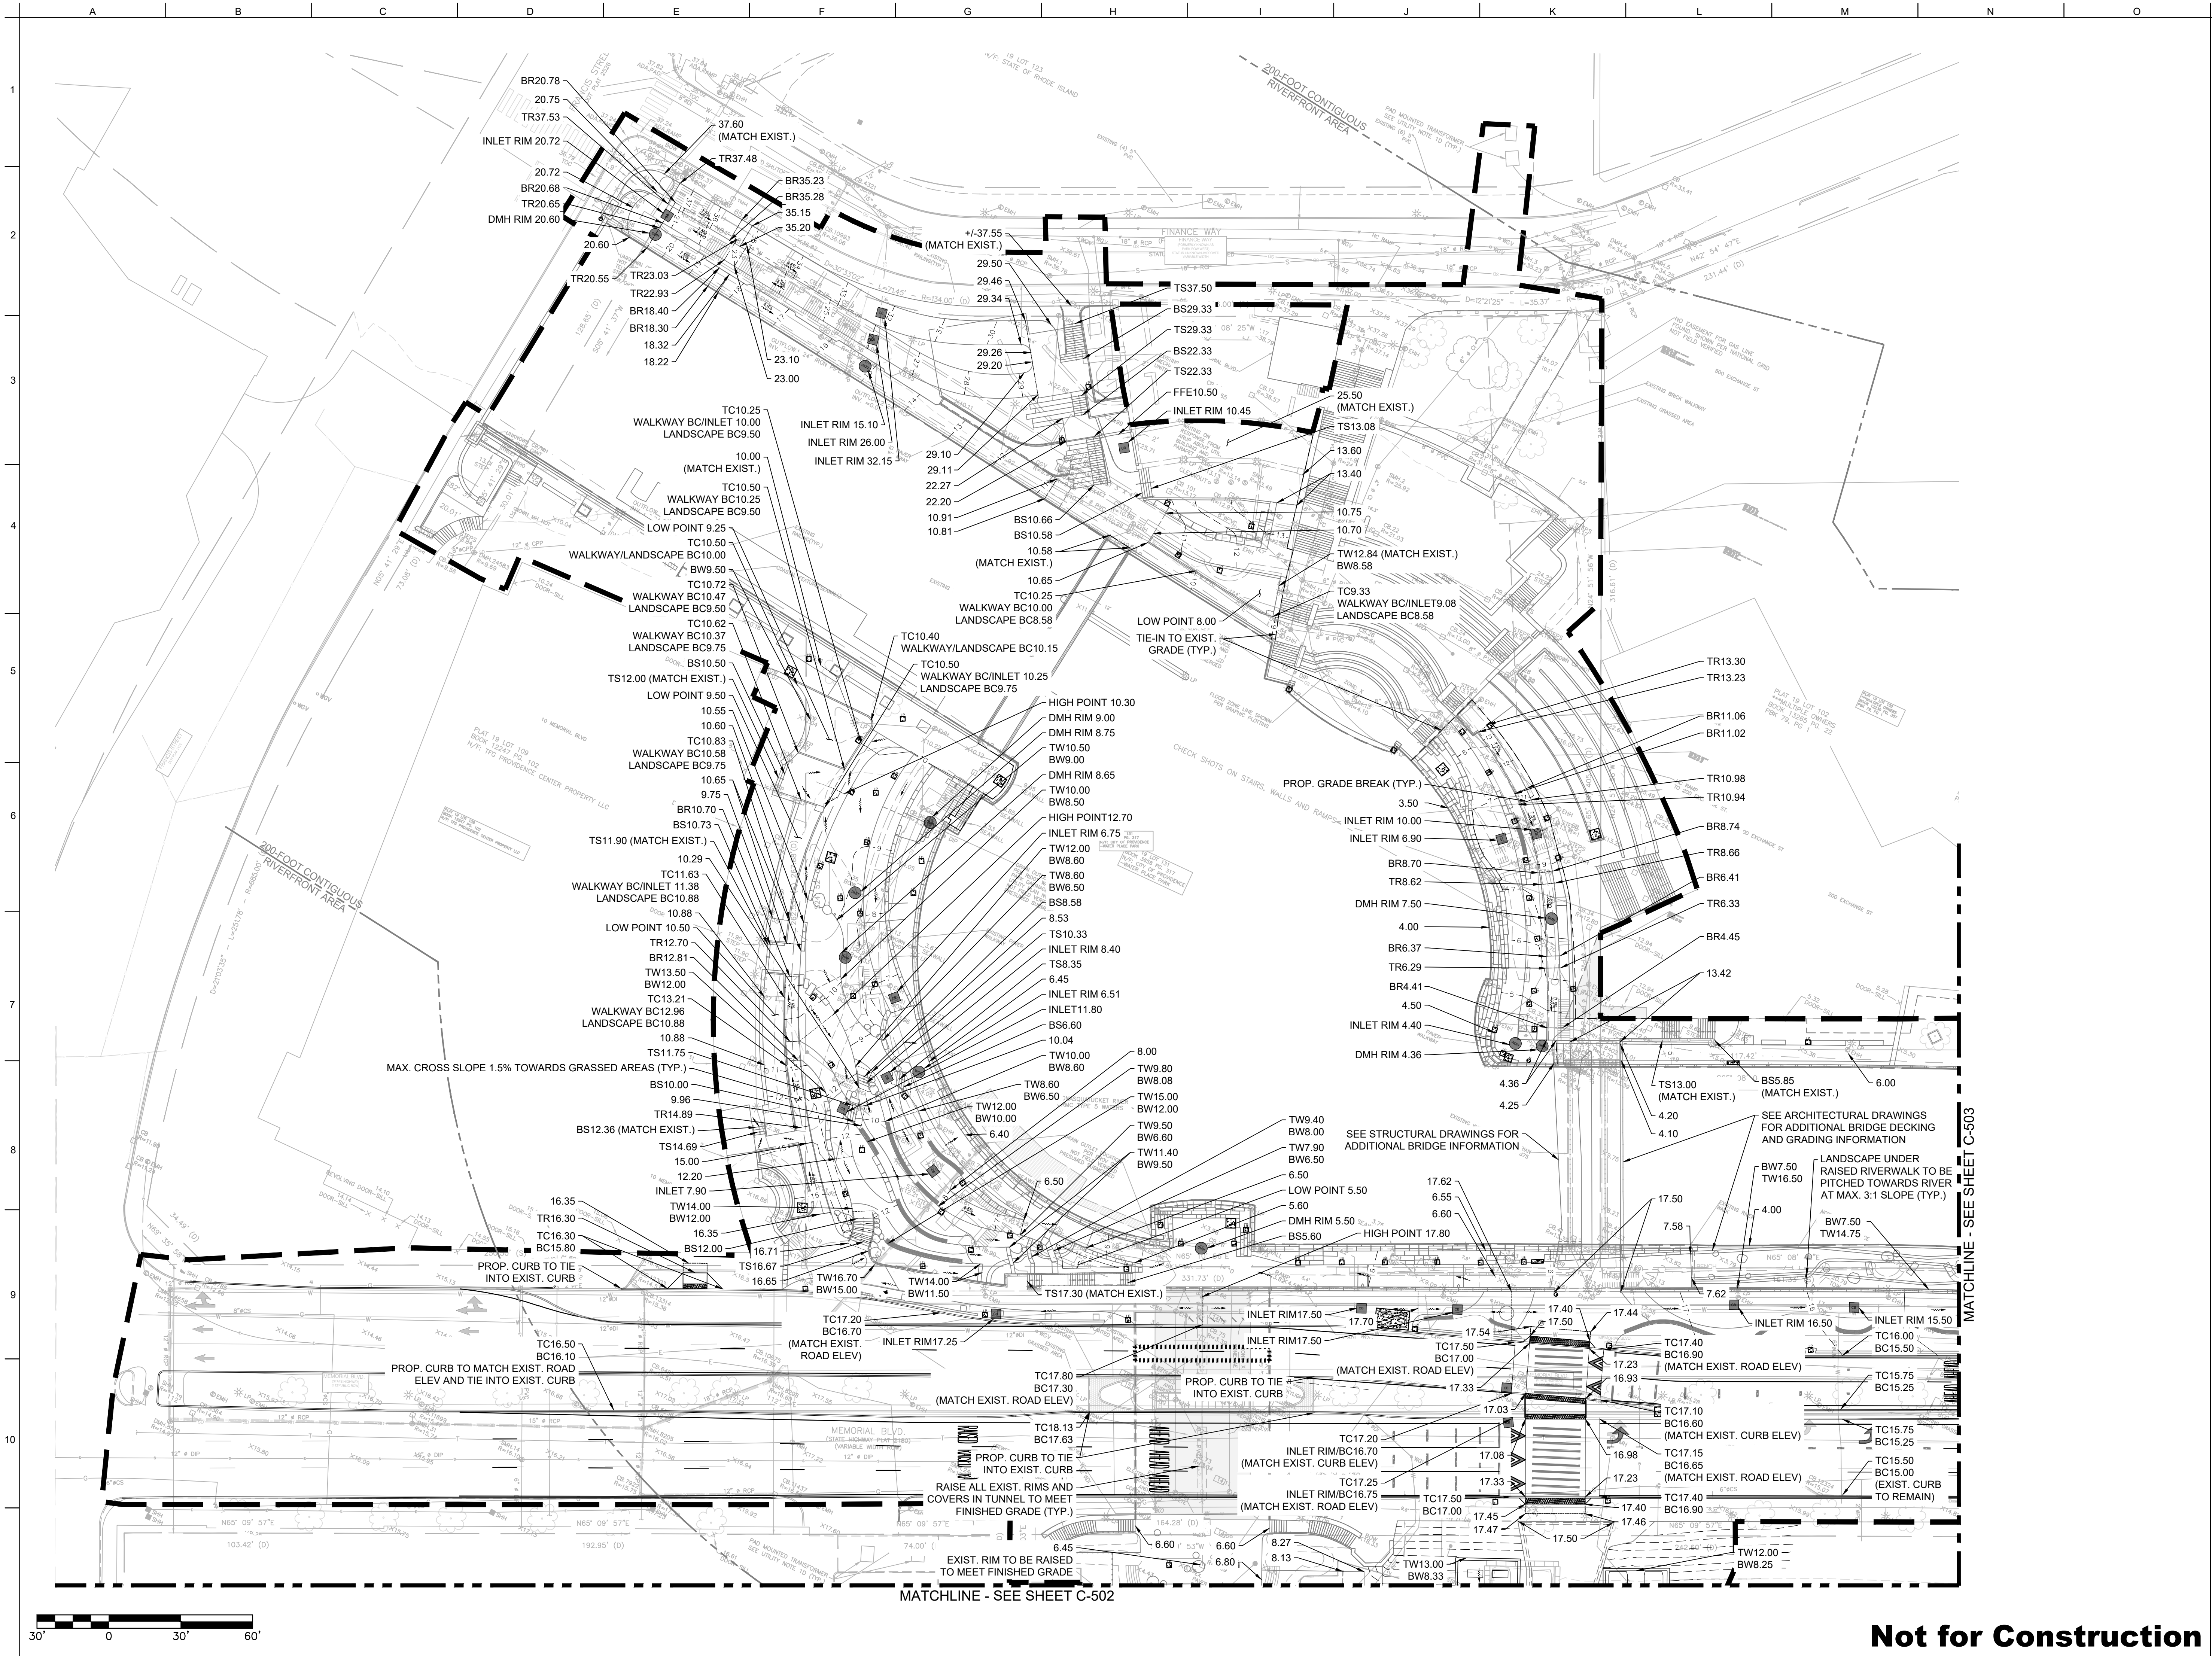

Arup US, Inc.
60 State Street
Boston MA 02109
T 617 864 2987
www.arup.com

Project Lead
Civil Engineering
Bridge Engineering
Structural Engineering
Electrical Engineering
Security
Lighting
Public Realm Technology
Fire Life Safety/Code
Fire Alarm
Mechanical Engineering
Plumbing Engineering
Fire Protection

Stephen Stimson Associates Landscape Architects, Inc.
Landscape Architecture
Cambridge, MA

In-form Studio
Architecture
Northville, MI

Vanasse Hangen Brustlin, Inc.
Traffic Engineering

RMA Environmental
Geoenvironmental Engineering
Marine Structures Engineering

Inter-Fluve, Inc.
Marine / Wetland Ecology

Narragansett Engineering, Inc.
Surveying
Portsmouth, RI

Issue	Date	Description

Client
Providence Department of Planning and Development

Project Title
**PROVIDENCE RIVERWALK
RESILIENCE
Riverwalk and Waterplace Park
Providence, RI**

Key Plan


Stamp

6/5/2026
B. DEREK ANDERSON
No. 15235
REGISTERED PROFESSIONAL ENGINEER
CIVIL

Drawing Name
**CIVIL
GRADING PLAN
WATERPLACE PARK**

Project Phase		90% DESIGN	
Disp	RK	Chid	ABR
Arup Job No.	303313-00	Revision	0
Drawing Number	C-501	Date	05/01/2026

Not for Construction

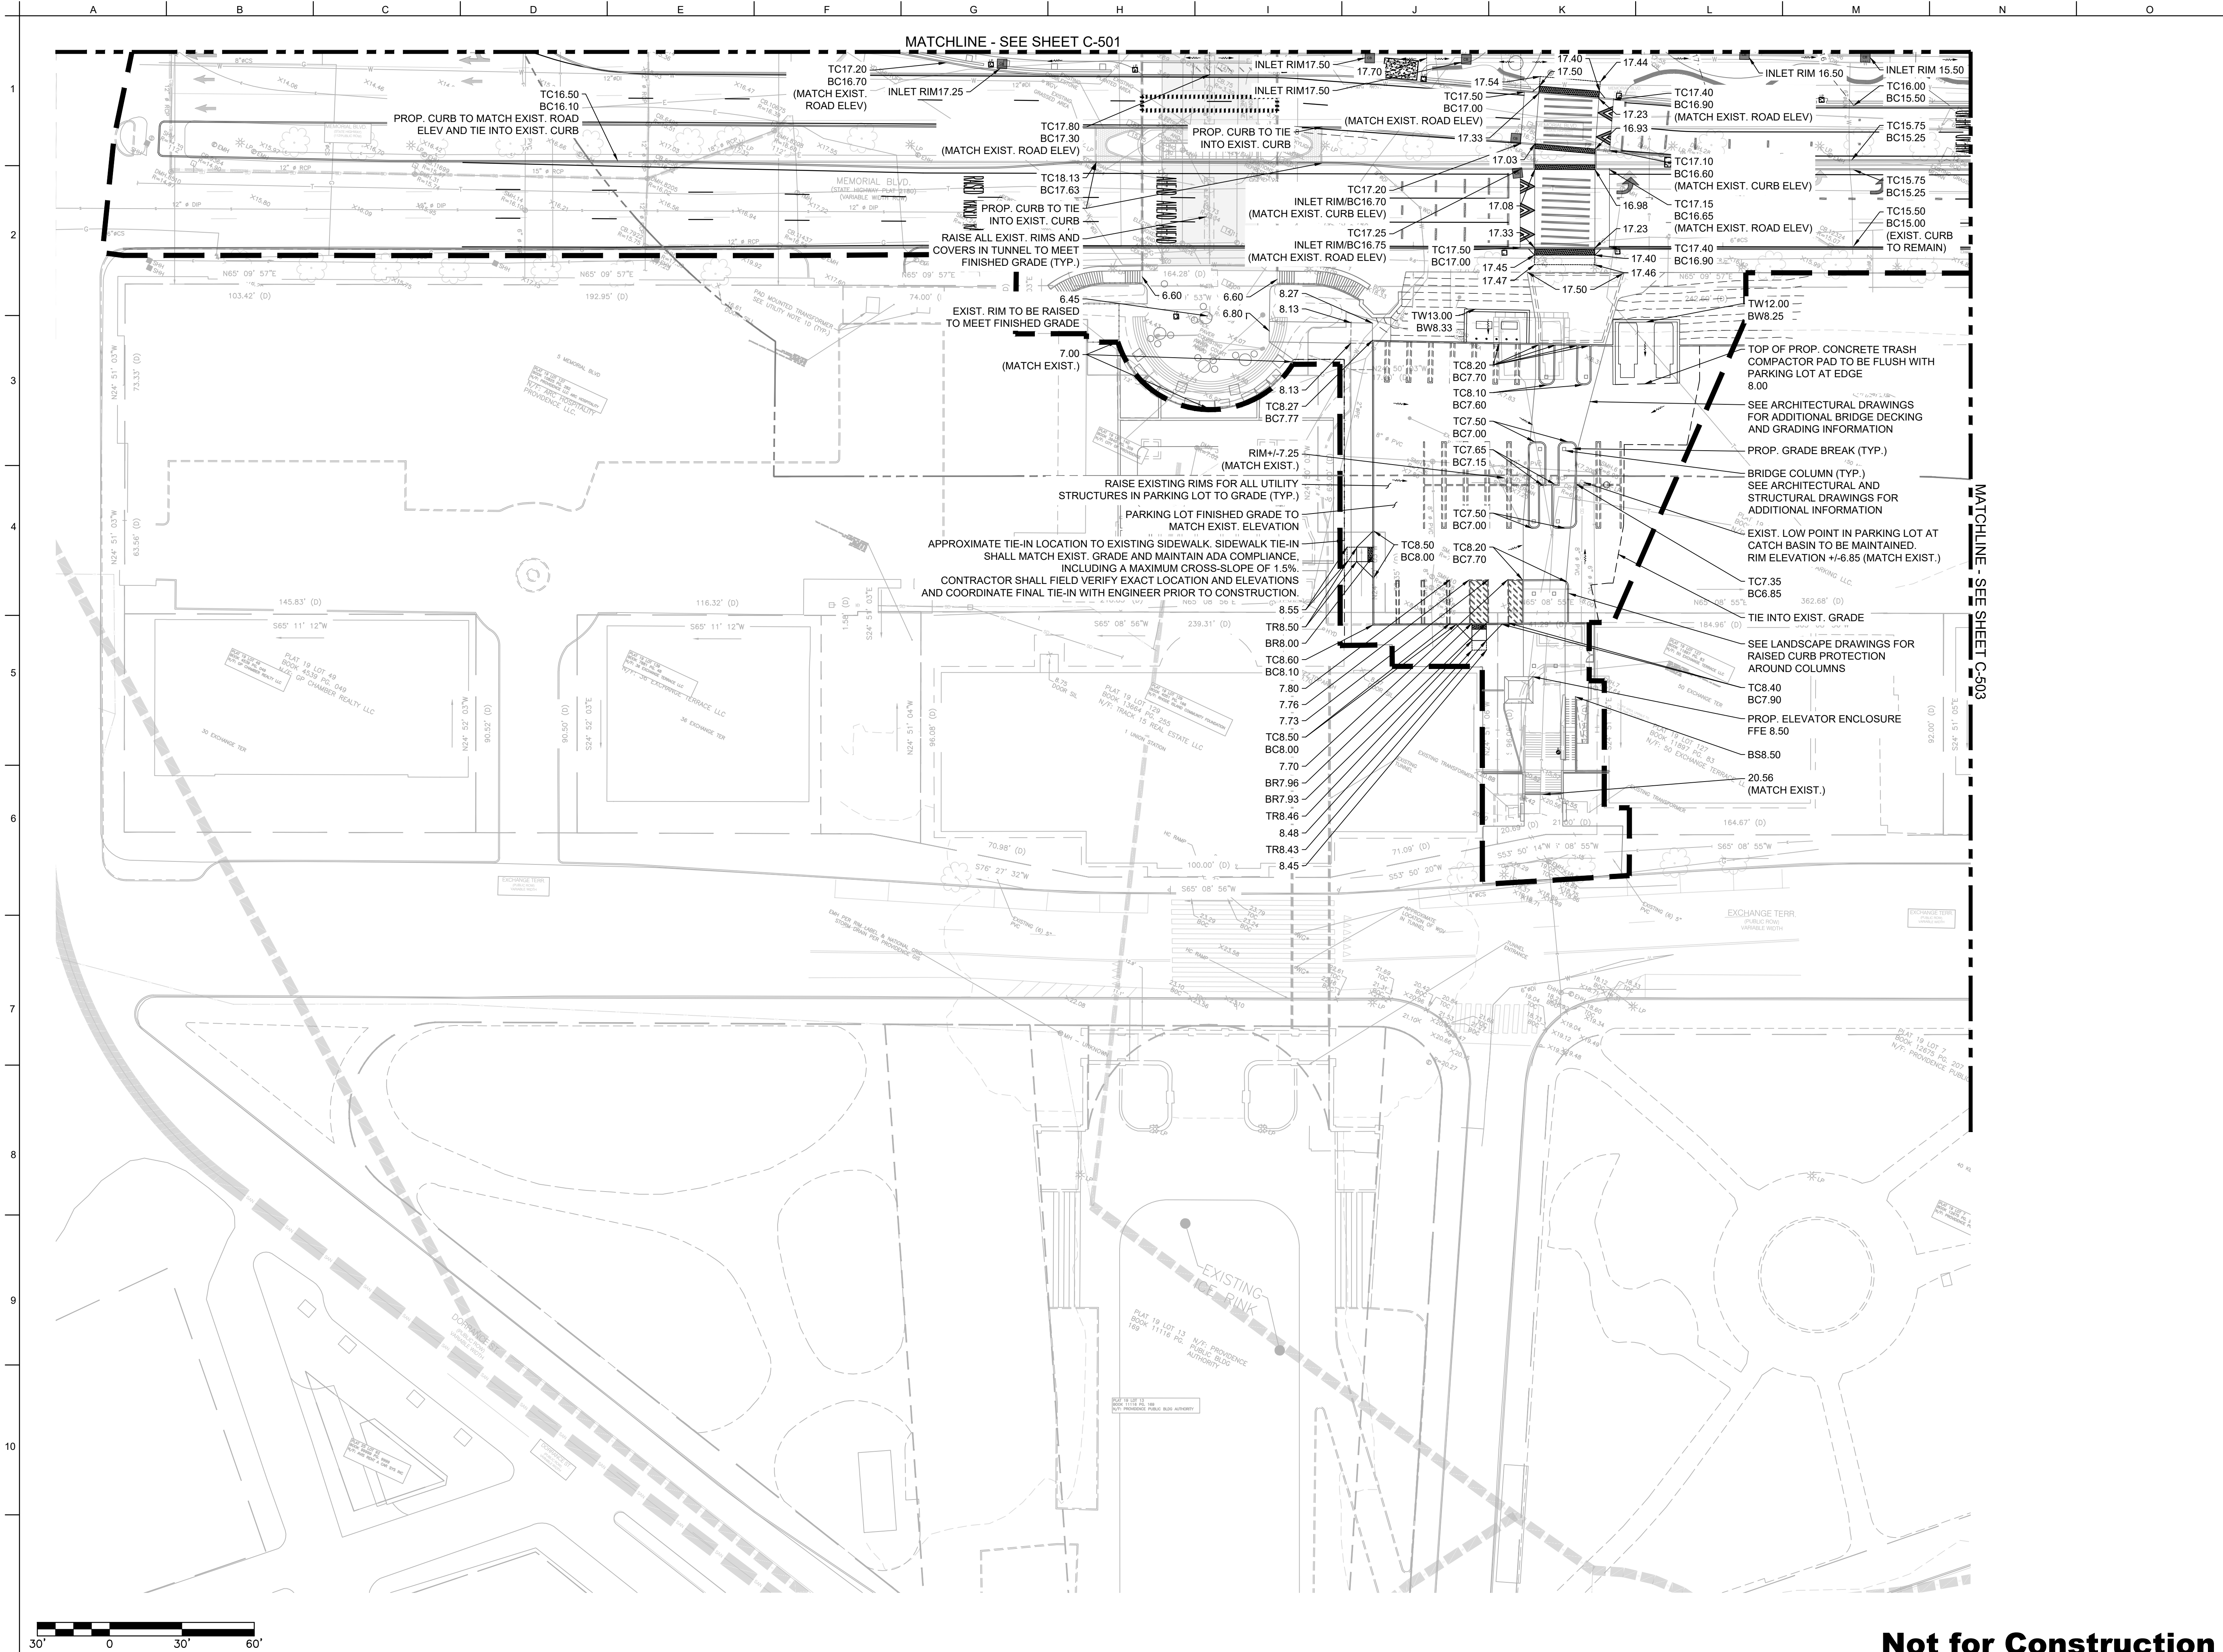

Not for Construction

ARUP

Arup US, Inc.
60 State Street
Boston MA 02109
T 617 864 2987
www.arup.com

Project Lead
Civil Engineering
Bridge Engineering
Structural Engineering
Electrical Engineering
Security
Lighting
Public Realm Technology
Fire Life Safety/Code
Fire Alarm
Mechanical Engineering
Plumbing Engineering
Fire Protection

Stephen Stimson Associates Landscape Architects, Inc.
Landscape Architecture
Cambridge, MA

In-form Studio
Architecture
Northville, MI

Vanasse Hangen Brustlin, Inc.
Traffic Engineering

RMA Environmental
Geoenvironmental Engineering
Marine Structures Engineering



Inter-Fluve, Inc.
Marine / Wetland Ecology

Narragansett Engineering, Inc.
Surveying
Portsmouth, RI

Issue	Date	Description
-------	------	-------------


Client
Providence Department of Planning
and Development

Project Title
PROVIDENCE RIVERWALK
RESILIENCE
Riverwalk and Waterplace Park
Providence, RI

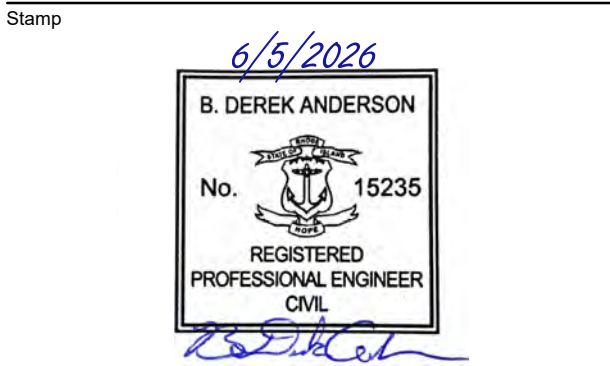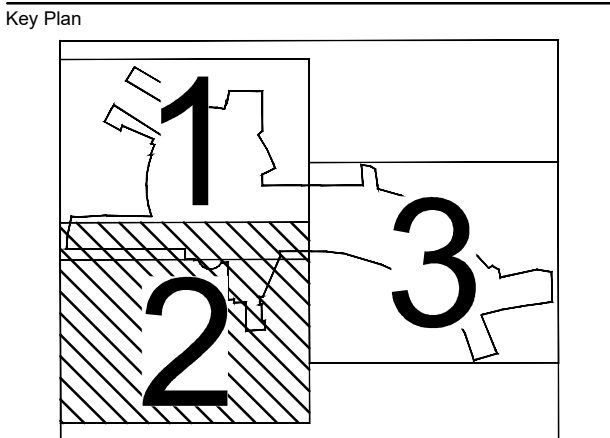

Drawing Name
CIVIL
GRADING PLAN
DOWNTOWN CONNECTOR

Project Phase		90% DESIGN	
Desg RK	Drw RK	Chkd ABR	Scale at ARCH D 1"=30'
Arup Job No 303313-00			Revision 0
Drawing Number C-502			Date 05/01/2026

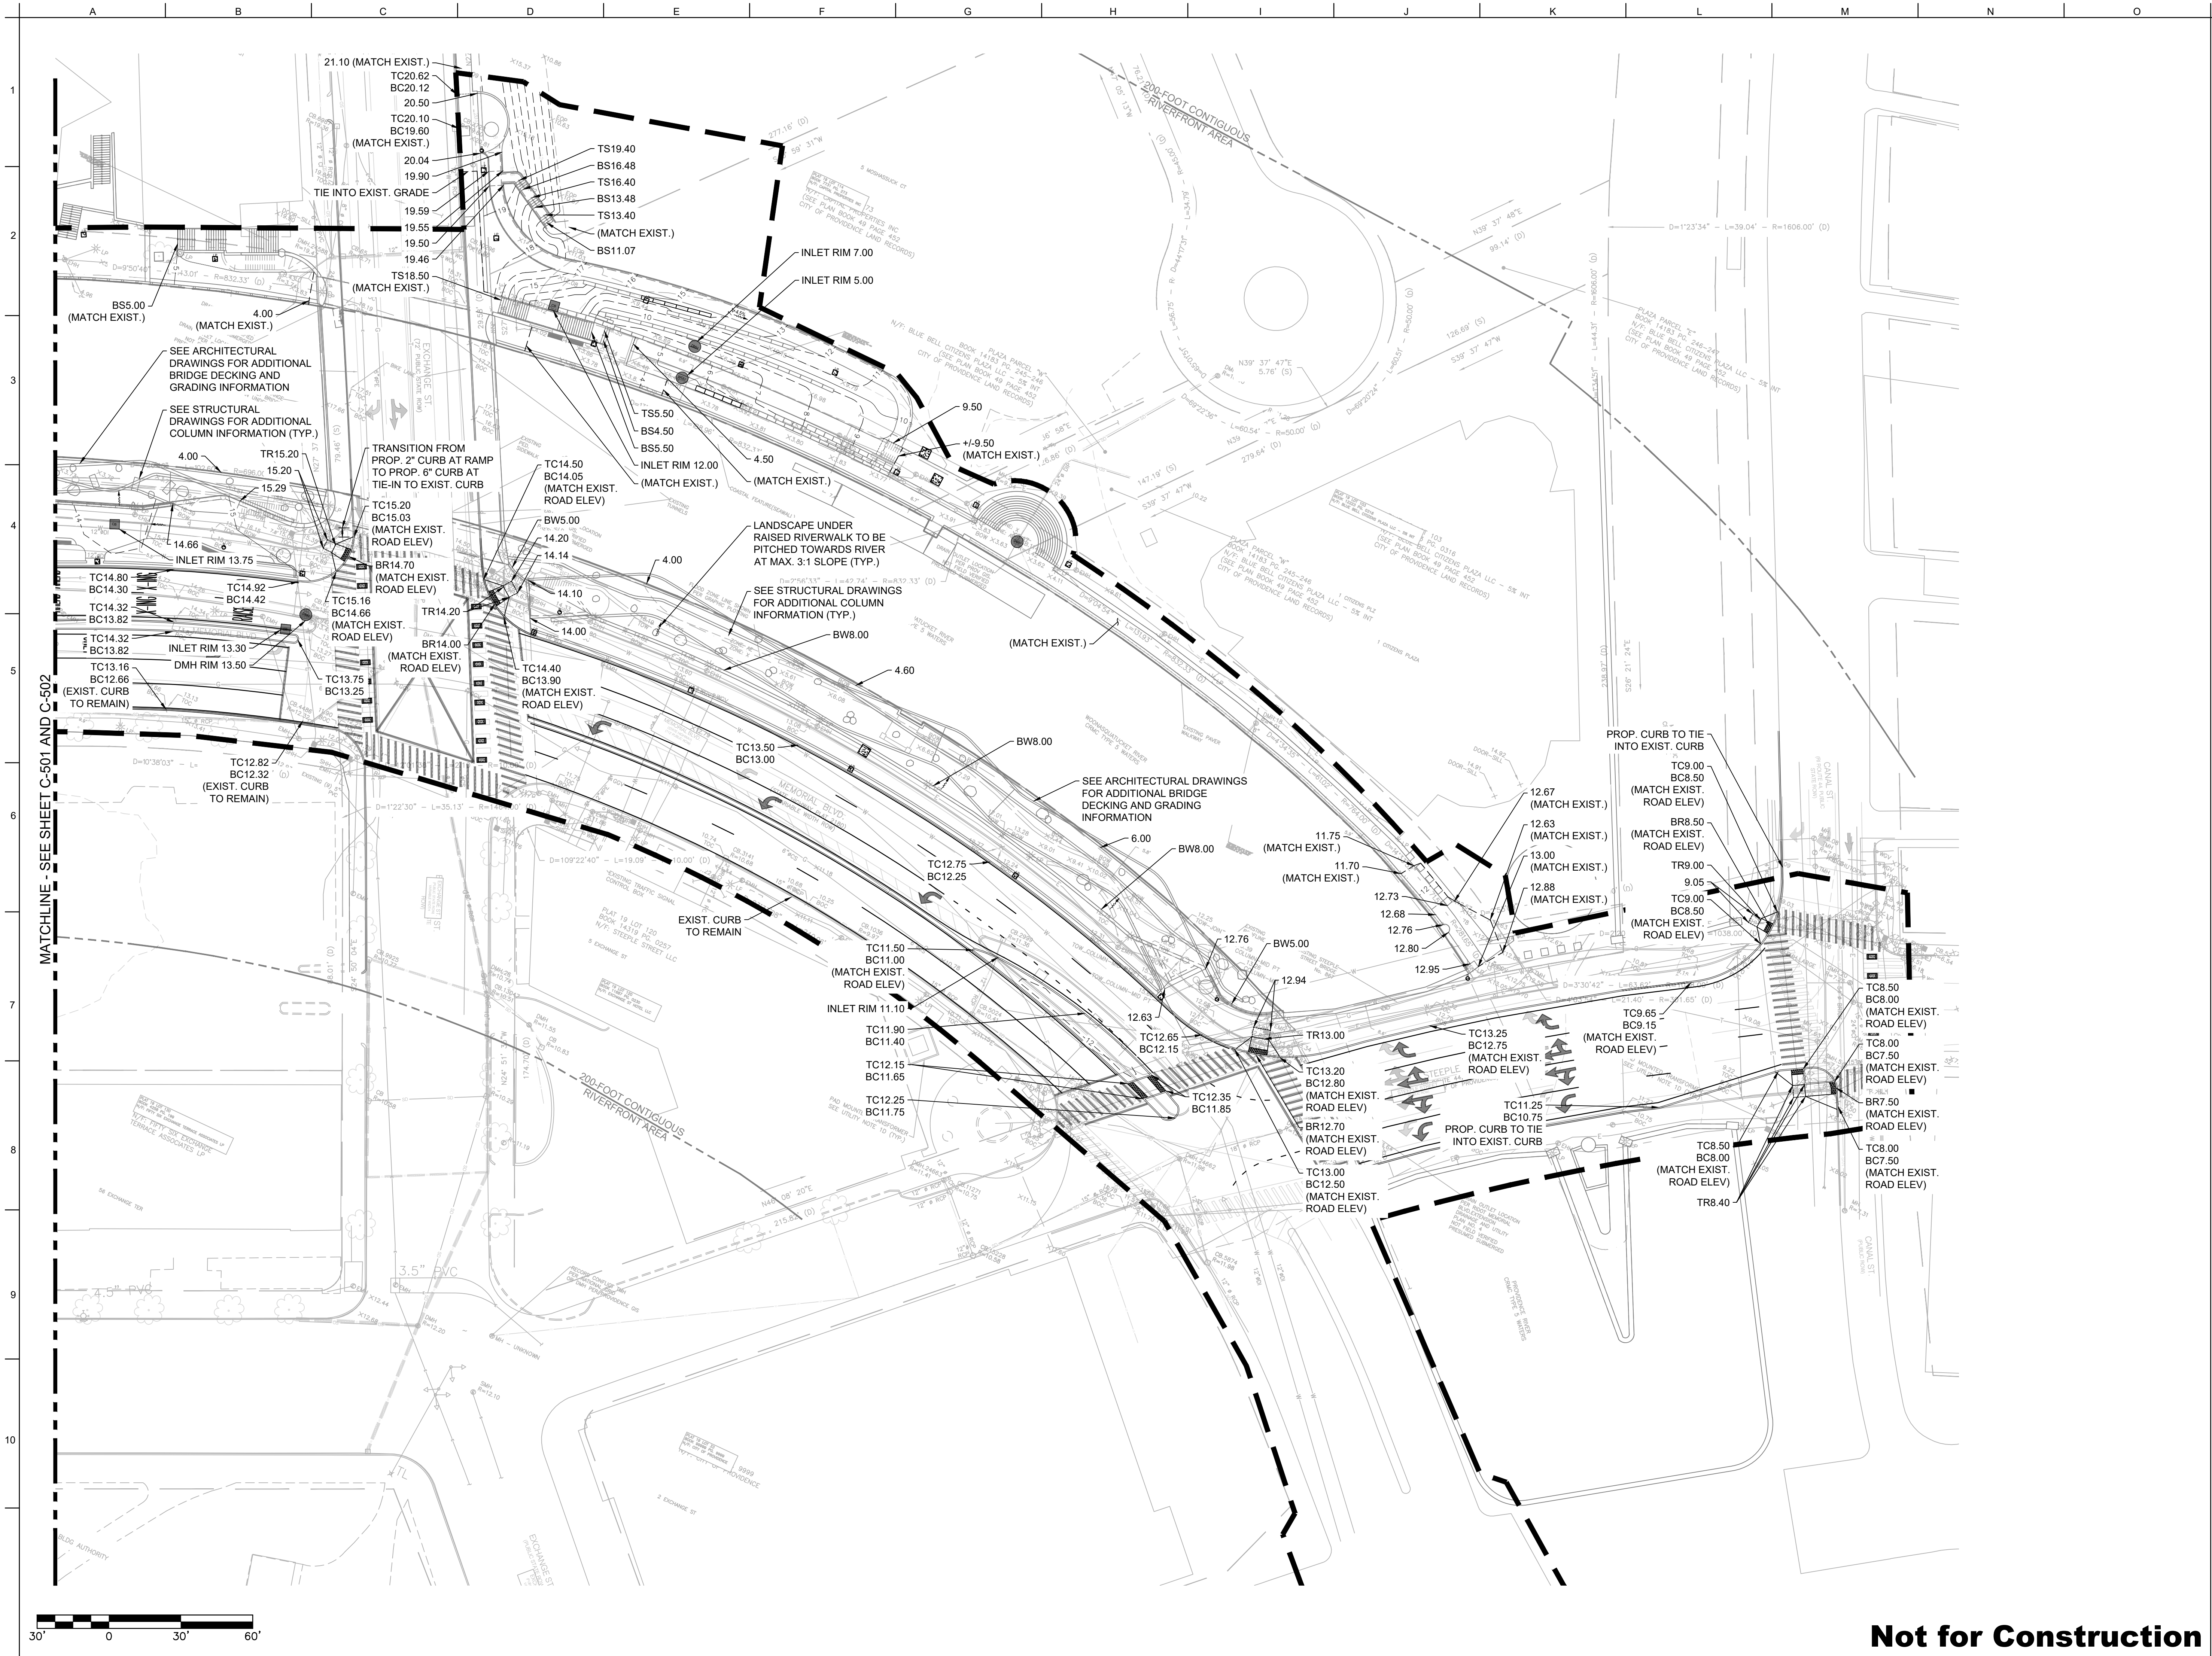

ARUP

Arup US, Inc.
60 State Street
Boston MA 02109
T 617 864 2987
www.arup.com

Project Lead
Civil Engineering
Bridge Engineering
Structural Engineering
Electrical Engineering
Security
Lighting
Public Realm Technology
Fire Life Safety/Code
Fire Alarm
Mechanical Engineering
Plumbing Engineering
Fire Protection

Stephen Stimson Associates Landscape Architects, Inc.
Landscape Architecture
Cambridge, MA

In-form Studio
Architecture
Northville, MI

Vanasse Hangen Brustlin, Inc.
Traffic Engineering

RMA Environmental
Geoenvironmental Engineering
Marine Structures Engineering

Inter-Fluve, Inc.
Marine / Wetland Ecology

Narragansett Engineering, Inc.
Surveying
Portsmouth, RI

Issue	Date	Description
1	6/5/2026	PROVIDENCE RIVERWALK RESILIENCE Riverwalk and Waterplace Park Providence, RI

Client
Providence Department of Planning and Development

Project Title
PROVIDENCE RIVERWALK RESILIENCE Riverwalk and Waterplace Park Providence, RI

Key Plan

Stamp

Drawing Name
CIVIL GRADING PLAN STEEPLE STREET

Project Phase	90% DESIGN
Disg RK	Drw RK
Arup Job No. 303313-00	Chkd ABR
Drawing Number C-503	Scale at ARCH D 1"=30'
	Revision 0
	Date 05/01/2026

Not for Construction